
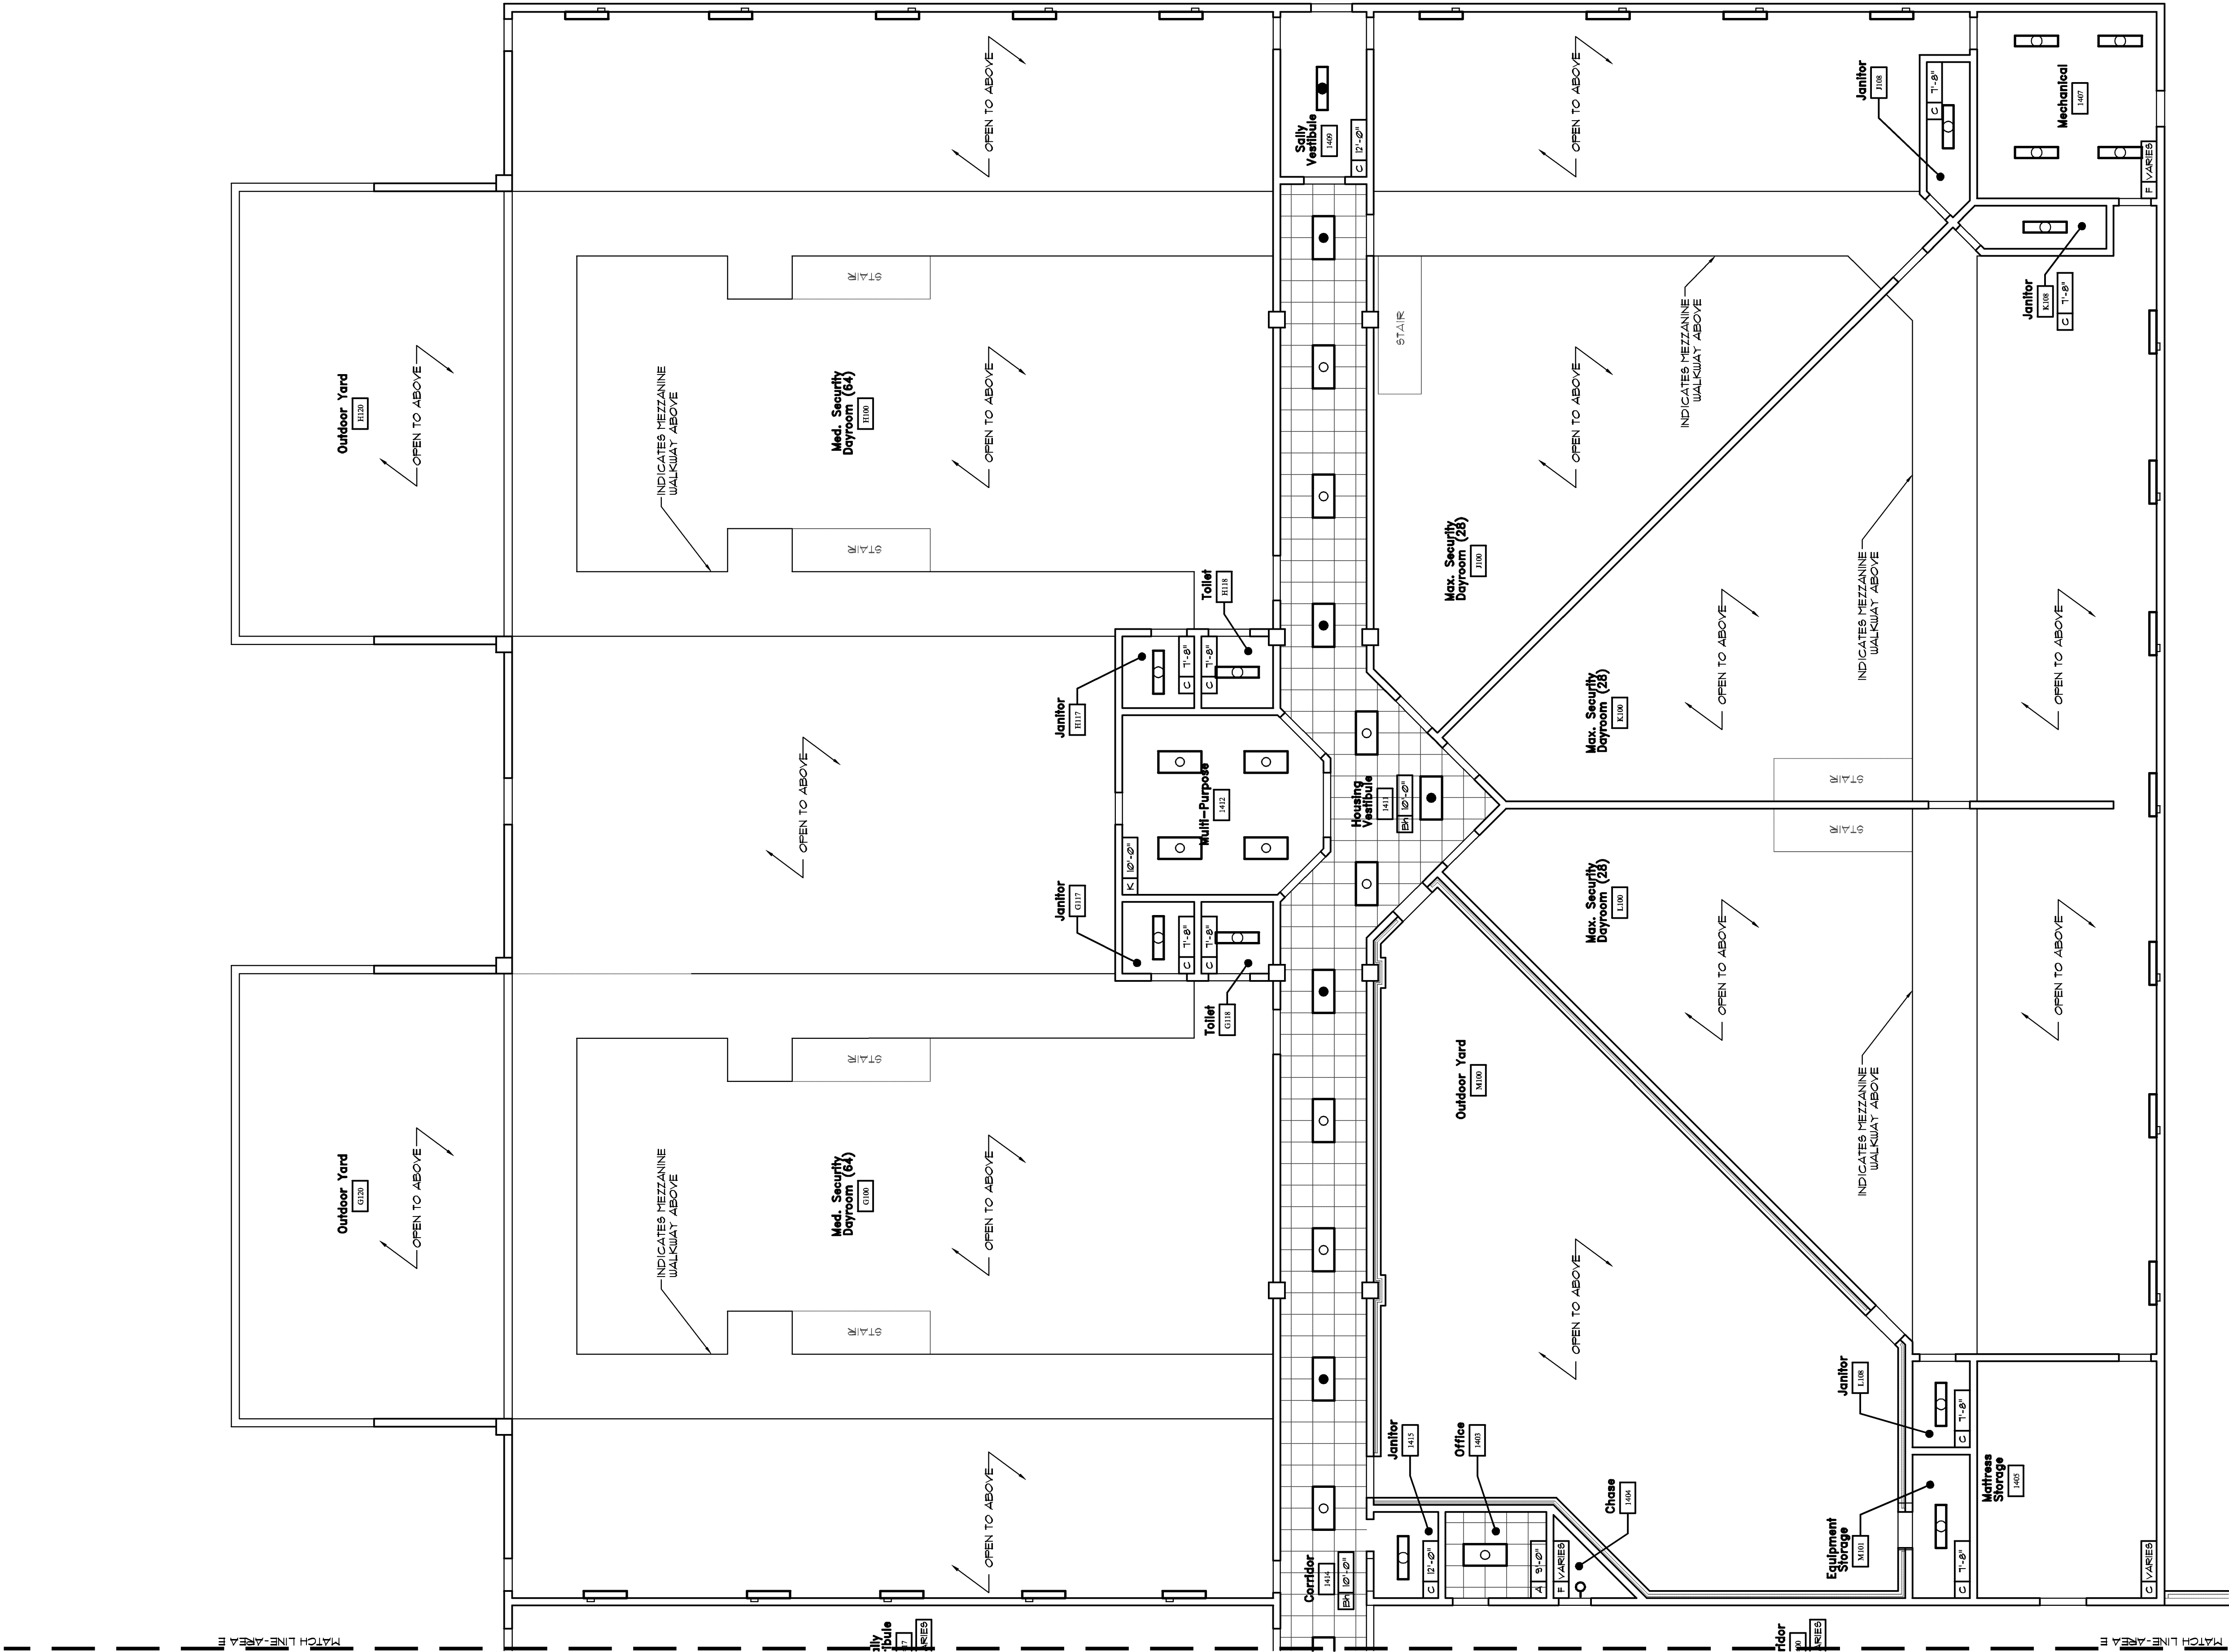


Job North

Reflected Ceiling Plan - Area 'E'

SCALE 1/8" = 1'-0"

1
A4.4

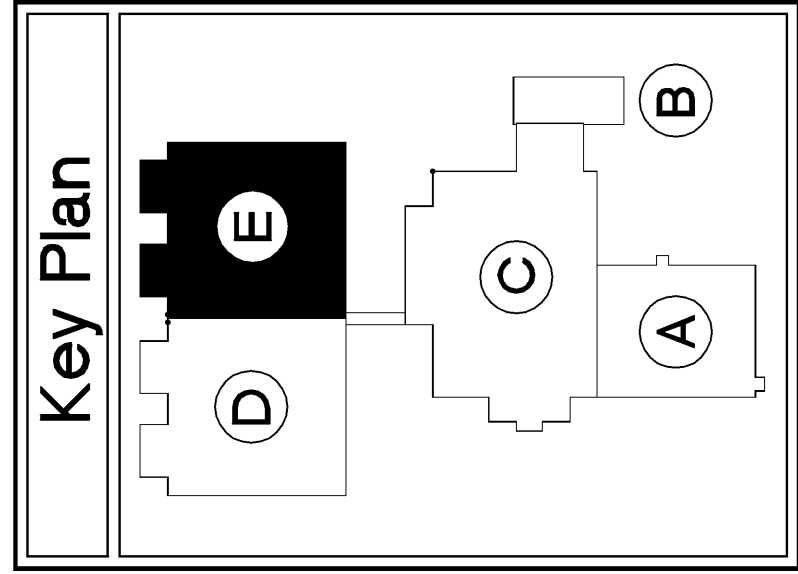

RELEASE

DATE	NO DESCRIPTION
03-28-08	
DATE	
12/21/07	MECHANICAL/ELECTRICAL BID PACKAGE RELEASE
03/28/08	BALANCE OF REMAINING BID PACKAGES
05/16/09/24	FIRE MARSHAL REVIEW COMMENTS

SHEET TITLE

LBD	DESIGN
FP	DRAWN
LBD	CHECKED

AREA "E"
CEILING PLAN
REFLECTED

PROJECT

JACKSON COUNTY JAIL
555 GENERAL JACKSON DRIVE
JEFFERSON, GEORGIA 30549

STAMP

REGISTERED ARCHITECT
STATE OF GEORGIA
LANE G. DAVIS
4-4-05

Precision Planning, Inc.
planners, engineers, architects & surveyors
P.O. Box 2210
400 Pike Boulevard
Lawrenceville, GA 30046-2210
(770) 338-8000 or (770) 962-8000
(Fax) (770) 822-5990

Ceiling Type Schedule

A	2'-x-2'	APC-1. RADAR 2'X2'X9'-8". REFER TO SPECIFICATIONS.
B	2'-x-2'	APC-3. HALCYON CLIMAPLUS 2'X2'X1" WITH NTC OF .50" - REFER TO SPECIFICATIONS.
C	2'-x-2'	PRECAST PLANK - PAINT. REFER TO STRUCTURAL.
D	2'-x-2'	NOT USED
E	2'-x-2'	APC-4. CLEAN ROOM CLIMAPLUS 2'X2'X9'-8". REFER TO SPECIFICATIONS.
F	2'-x-2'	OPEN TO STRUCTURE - NOT PAINTED. REFER TO STRUCTURAL.
G	2'-x-2'	2 LAYERS OF 5/8" TYPE X GYPSUM BOARD ON LIGHT GAUGE METAL FRAMING. ALL PENETRATIONS THRU CEILING TO PROVIDE FIRE PROOF ASSEMBLY.
H	2'-x-2'	APC-2. RADAR CLIMAPLUS 2'X2'X9'-8". REFER TO SPECIFICATIONS.
I	2'-x-2'	5/8" FIBEROCK AQUA-TOUGH GYPSUM BOARD CEILING ON LIGHT GAUGE METAL FRAMING - PAINT.
K	2'-x-2'	5/8" FIBER-REINFORCED HIGH IMPACT GYPSUM BOARD CEILING ON LIGHT GAUGE METAL TRACING - PAINT.
L	2'-x-2'	APC-5. TECHT LAY-IN CEILING PANEL 2'X2'X1". REFER TO SPECIFICATIONS.
M	2'-x-2'	OPEN TO STRUCTURE - PAINT. REFER TO STRUCTURAL.
N	2'-x-2'	5/8" GYPSUM PANEL SUSPENDED ON LIGHT GAUGE METAL FRAMING - PAINT.

CEILING TYPE MODIFIERS

24	2'-x-2'	INSTALL HOLOCON CLIPS.
----	---------	------------------------

1. CENTER CEILING GRIDS IN BOTH DIRECTIONS IN ALL CORRIDORS AND IN EACH ROOM. ALL CORRIDORS AND ROOMS SHALL INSTALL CEILING TRACKS MINIMUM 6" FROM WALL SURFACES IN ALL DIRECTIONS.
2. CENTER ALL INTERIOR DOWNLIGHTS IN CEILING TILES. IN ROOMS WITHOUT CEILING TILES, CENTER DOWNLIGHTS IN BOTH DIRECTIONS TO RELATIVE WALLS.
3. CENTER ALL SECURITY AND NON-SECURITY WALL MOUNTED VANITY FIXTURES OVER MIRRORS BELOW.
4. CENTER 2'X4 1/4" AND 2'X2 SURFACE MOUNTED FIXTURES IN BOTH DIRECTIONS OF SPACES.
5. FOR SPECIFICATIONS OF EACH FIXTURE TYPE REFER TO ELECTRICAL DRAWINGS.
6. CENTER ALL SPRINKLER HEADS IN CEILING TILES WHERE APPLICABLE.
7. PRODUCT TYPES INDICATED ARE BASIS OF DESIGN - REFER TO SPECIFICATIONS.
8. CONTRACTOR SHALL VERIFY FIXTURES WITH HVAC GRILLES. CONTACT CONTRACTOR'S COORDINATOR FOR COORDINATION.
9. CEILING HEIGHTS IN AREAS WITH DEPRESSIONED SLAB SHALL BE HEADRED FROM OVERALL BUILDING FINISH FLOOR- NOT INCLUDING DEPRESSIONED SLAB.
10. PROVIDE ADEQUATE ACCESS TO EQUIPMENT FITTINGS, VALVES, ETC. THAT ARE NOT EXPOSED ABOVE CEILINGS AND BEHIND WALL FINISHES. OPENINGS SHALL BE PROTECTED WITH A MINIMUM OF 1" MINIMUM RESISTANCE RATING OF THE BARRIER PER NFPA 101 LIFE SAFETY CODE.
11. PROVIDE GYPSUM WALL BOARD EXPANSION JOINTS AT 20'-0" O.C. AS REQUIRED IN BULKHEADS.
12. CONTRACTOR TO COORDINATE ALL ROOF OPENINGS WITH STRUCTURE ENGINEER. ALL ROOF OPENINGS SHALL BE PROTECTED WITH MINIMUM 1" MINIMUM RESISTANCE RATING OF THE BARRIER PER NFPA 101 LIFE SAFETY CODE.
13. ALL GYPSUM BOARD IN SECURE AREAS SHALL BE VERY HIGH IMPACT RESISTANT GYPSUM BOARD.

R.C.P. Symbol Legend

CEILING TYPE	CEILING HEIGHT
	9'-6"
MODIFIER	

Ceiling Legend

	2x4 FLUORESCENT LIGHT FIXTURE
	2x2 FLUORESCENT LIGHT FIXTURE
	SURFACE MOUNTED FLUORESCENT LIGHT FIXTURE
	FLUORESCENT LIGHT FIXTURE - WALL MOUNTED
	FLUORESCENT HIGH BAY FIXTURE
	REFER TO ELECTRICAL DRAWINGS FOR EXIT SIGN LOCATIONS EMERGENCY LIGHT
	WALL MOUNTED SCONCE
	RECESSED CAN LIGHT
	HVAC SUPPLY DIFFUSER
	HVAC RETURN AIR GRILLE
	800 LIGHT - REFER TO AS3 - CONTRACTOR SHALL COORDINATE ALL STRUCTURE, MECHANICAL, ELECTRICAL, AND FIRE PROTECTION INSTALLATION JACKSON AND FIRE PROTECTION INSTALLATION JACKSON AND FIRE PROTECTION
	800 LIGHT - REFER TO AS3 - CONTRACTOR SHALL COORDINATE ALL STRUCTURE, MECHANICAL, ELECTRICAL, AND FIRE PROTECTION INSTALLATION JACKSON AND FIRE PROTECTION

NOTE: REFER TO ELECTRICAL AND MECHANICAL DRAWINGS FOR FIXTURE DETAILS.