

FILE NUMBER
CADD FILE NAME
PROJECT NUMBER
DATE

136A4-11.dwg
A06136
03-28-08

RELEASE

NO

DESCRIPTION

12/21/07

MECHANICAL/ELECTRICAL BID PACKAGE RELEASE

03/28/08

BALANCE OF REMAINING BID PACKAGES

SHEET TITLE

AREA D MEZZANINE
CEILING PLAN

DESIGN

LD

CAC

LD

CHECKED

LD

PROJECT

JACKSON COUNTY JAIL
JEFFERSON, GEORGIA 30549

STAMP


REGISTERED ARCHITECT
STATE OF GEORGIA
LANE G. DAVIS
4-4-05

PRECISION PLANNING, INC.
P.O. Box 2210
400 Pike Boulevard
Lawrenceville, GA 30046-2210
(770) 338-8000 or (770) 962-8000
(Fax) (770) 822-5990

planners, engineers, architects & surveyors

2008

PRECISION PLANNING, INC.
ALL RIGHTS RESERVED.

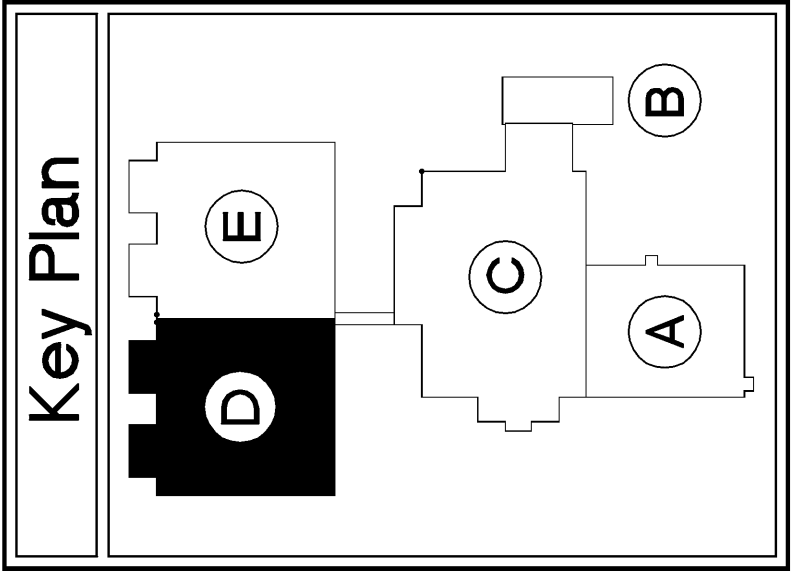


Security Ceiling Legend

SECURITY CEILING PRECAST PLANKS

SKYLIGHT - REFER TO A31 AND A32 - CONTRACTOR TO COORDINATE ALL STRUCTURAL, MECHANICAL, ELECTRICAL, PIPING AND FIRE PROTECTION INSTALLATION AROUND SKYLIGHT.

SKYLIGHT - REFER TO A31 AND A32 - CONTRACTOR TO COORDINATE ALL STRUCTURAL, MECHANICAL, ELECTRICAL, PIPING AND FIRE PROTECTION INSTALLATION AROUND SKYLIGHT.

PARTITION EXTENDING FROM FINISH FLOOR TO UNDERSIDE OF ROOF DECK OR TOP OF PARAPET.

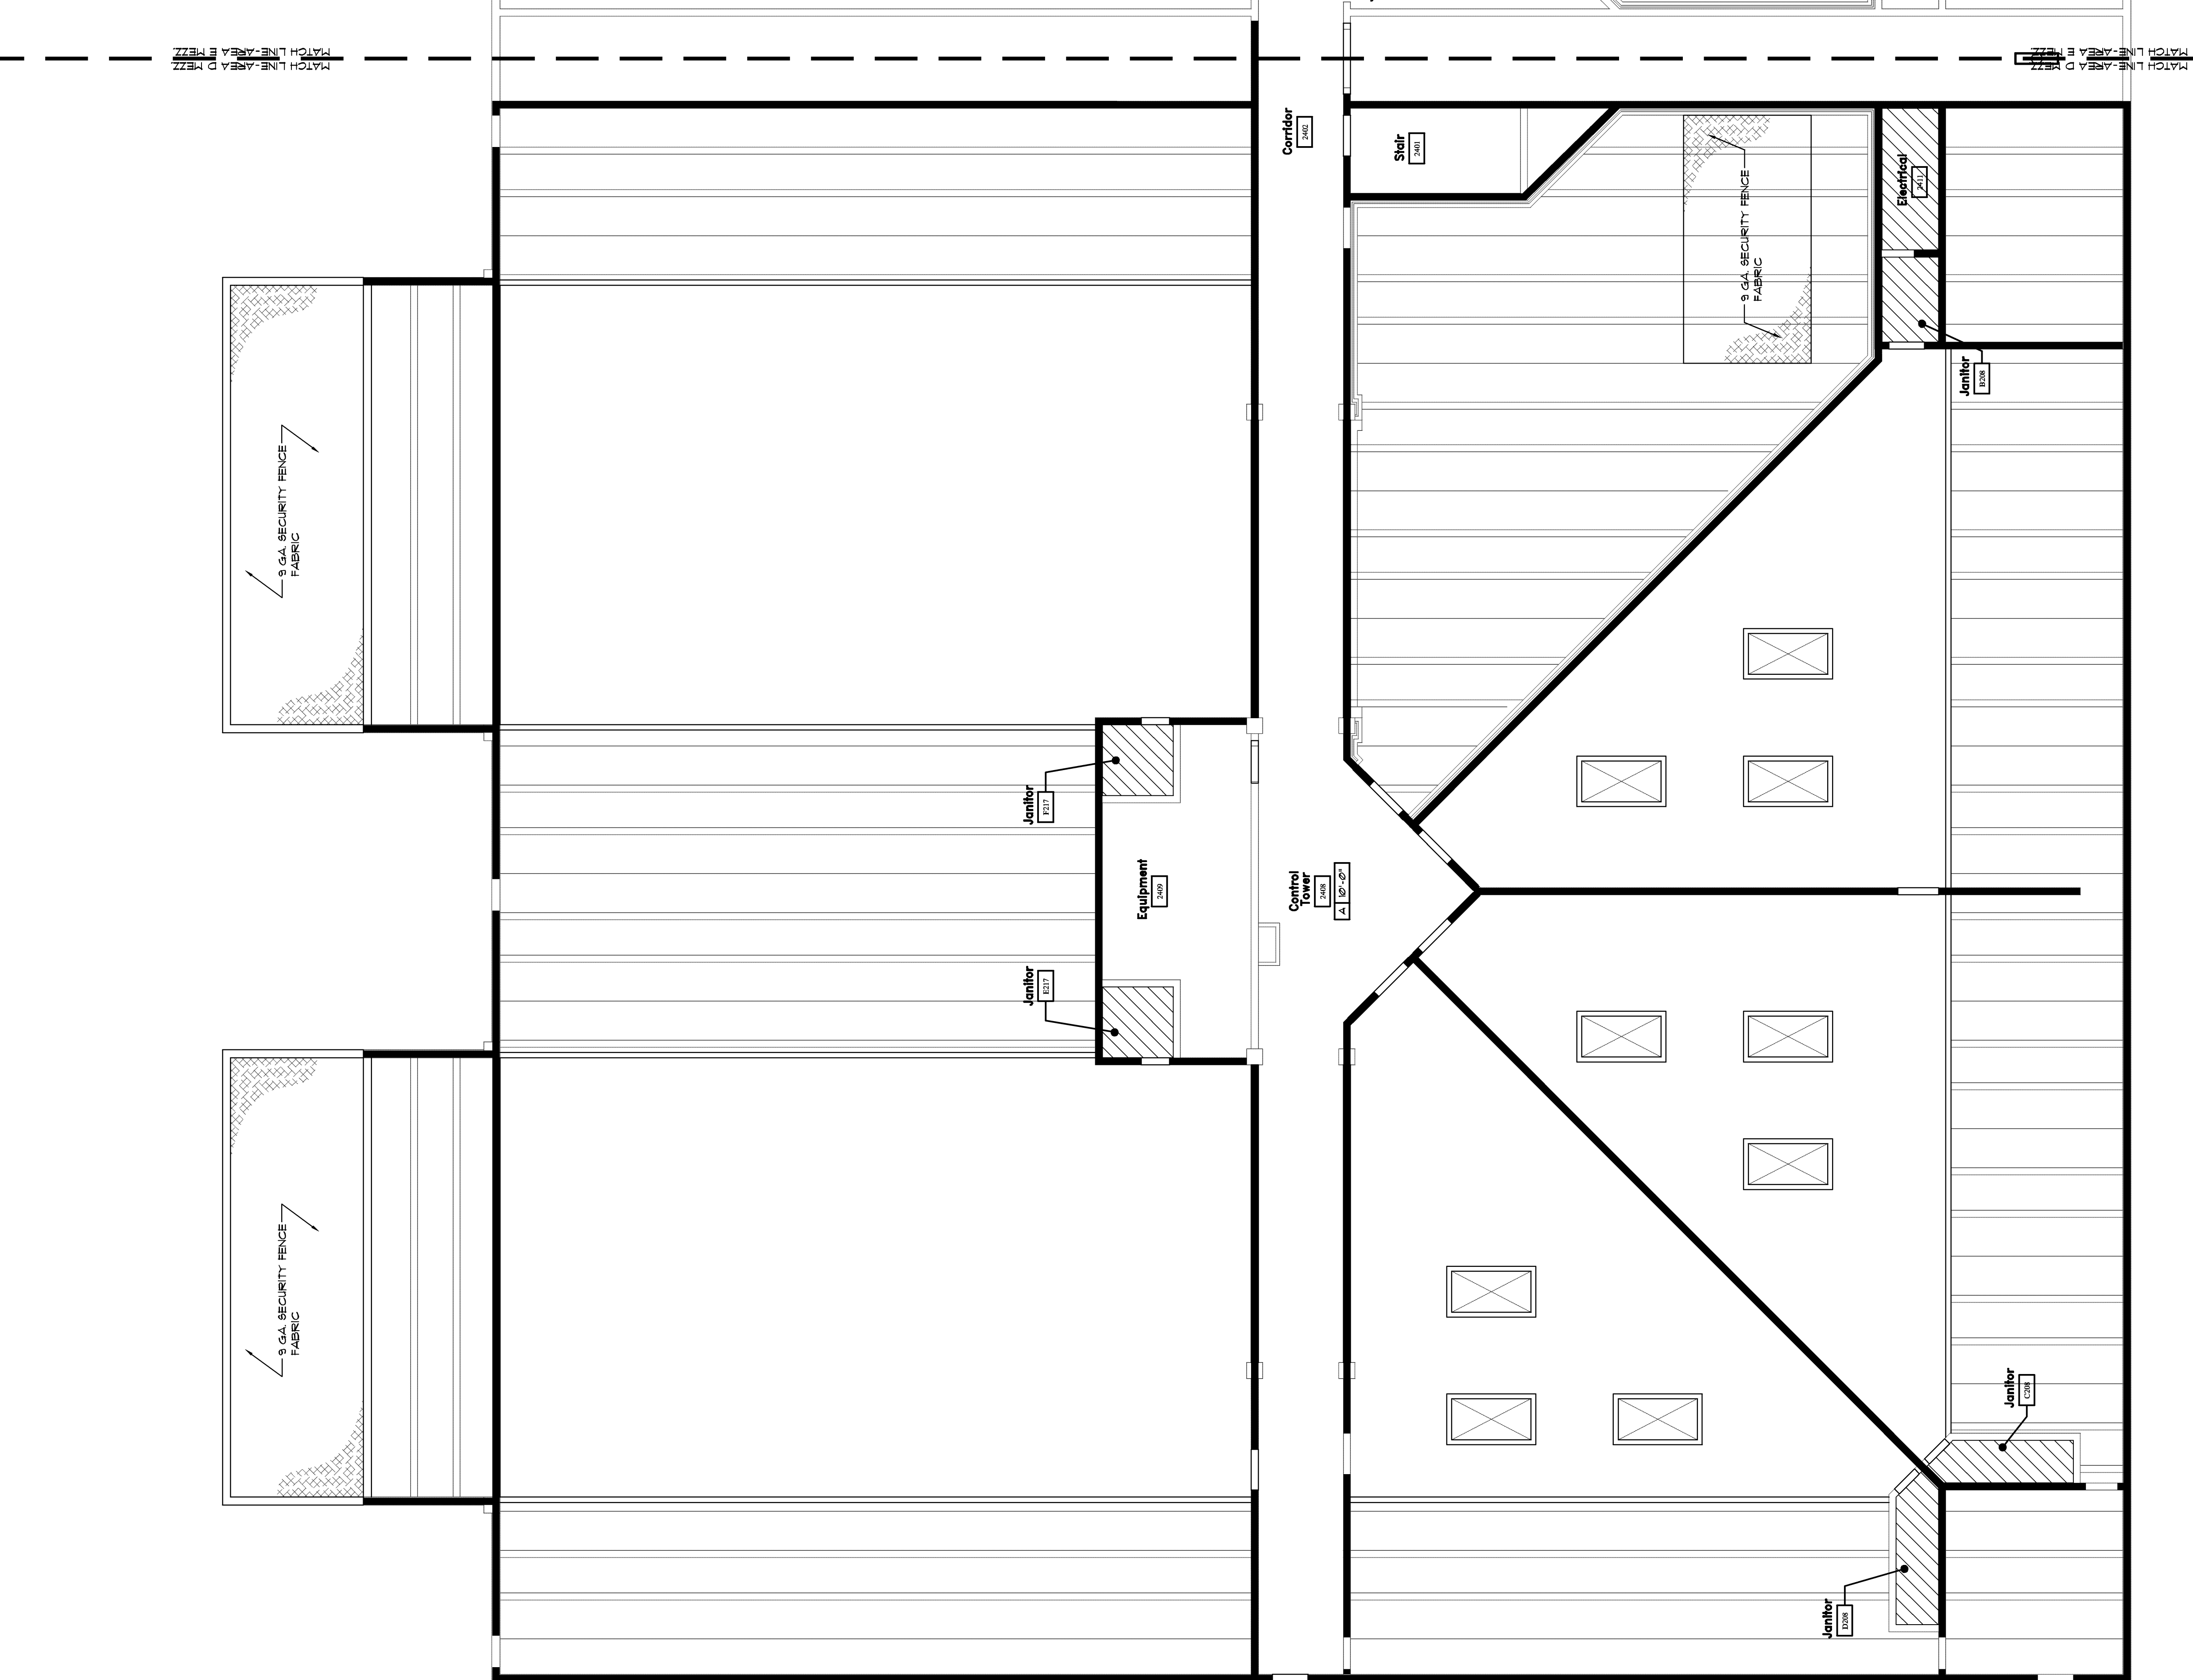

1
A4.11

SCALE 1/8" = 1'-0"

Reflected Ceiling Plan - Area 'D' - Mezzanine

Job North