


P-1.2		FILE NUMBER CAD FILE NAME 0608P1-2 PROJ. NUMBER A0836 DATE 10-31-07		RELEASE DATE NO. DESCRIPTION 10/31/07 D.E.C. / PLUMBING BID PACKAGE RELEASE 02/23/08 M.P.C. COORDINATION		SHEET TITLE PLUMBING AREA 'C' PLAN DWG DESIGN F.L.T. DRAWN F.L.T. CHECKED C.D.L.		PROJECT JACKSON COUNTY JAIL 555 GENERAL JACKSON DRIVE JEFFERSON, GEORGIA 30549		Precision Planning, Inc. planners, engineers, architects & surveyors P.O. Box 2210 400 Pike Boulevard Louisville, GA 30046-2210 (770) 962-8000 or (770) 962-8006 (Fax) (770) 822-5990		STAMP GEORGIA PRECISION PLANNING, INC. 12540 P.E. 10/31/07	
-----------------------------	--	--	--	---	--	--	--	---	--	--	--	---	--



1	PLUMBING PLAN DWG - Area 'C'
P-12	SCALE 1/8" = 1'-0"

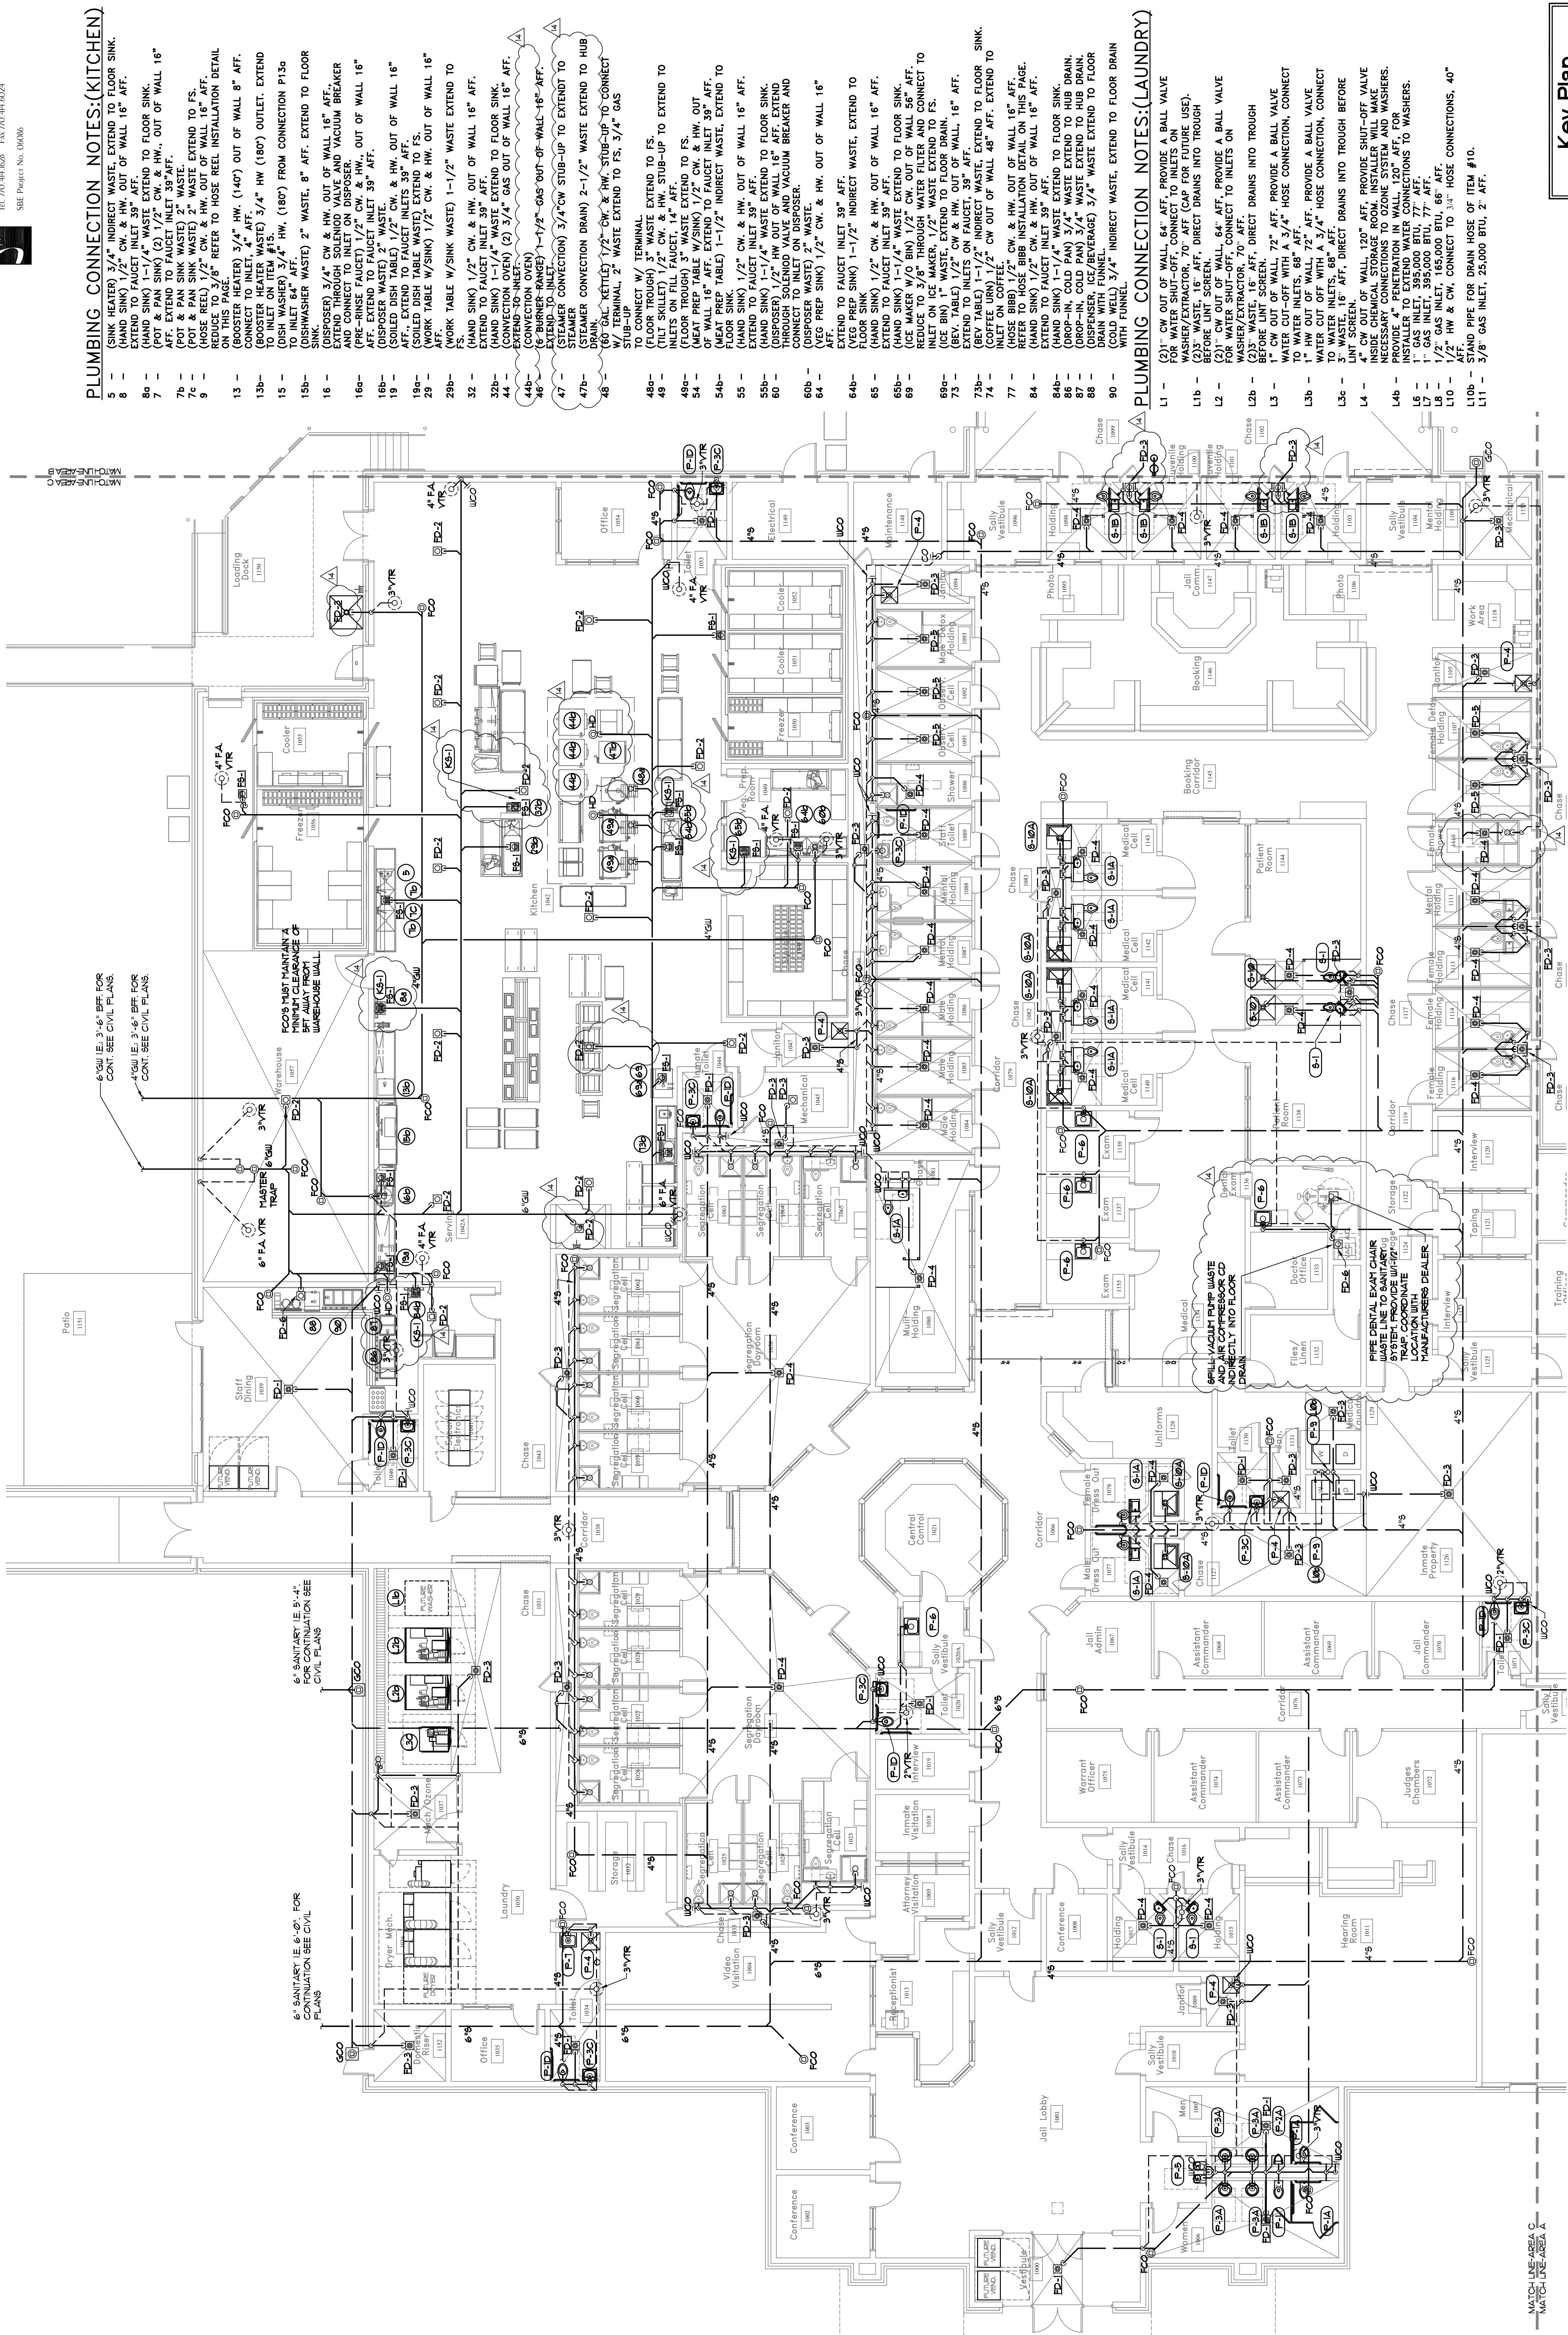