



NO	DESCRIPTION	DATE	REVISION	REVISION DESCRIPTION
1	DESCRIPTION			
2	MECHANICAL / ELECTRICAL BID PACKAGE RELEASE			
3	AS#007 REVISIONS TO FIRE ALARM DEVICES			
4	REV #24 FIRE MARSHAL REVIEW COMMENTS			

SHEET TITLE		
JBL DESIGN	JBL DRAWN	JBL CHECKED
ELECTRICAL PLAN AREA 'E' MEZZANINE		

JACKSON COUNTY JAIL
555 GENERAL JACKSON DRIVE
JEFFERSON, GEORGIA 30549

Precision Planning, Inc.
planners, engineers, architects & surveyors

P.O. Box 2210
Livermoreville, GA 30046-2210
(770) 338-8000 or (770) 962-8000
(fax) (770) 822-5990

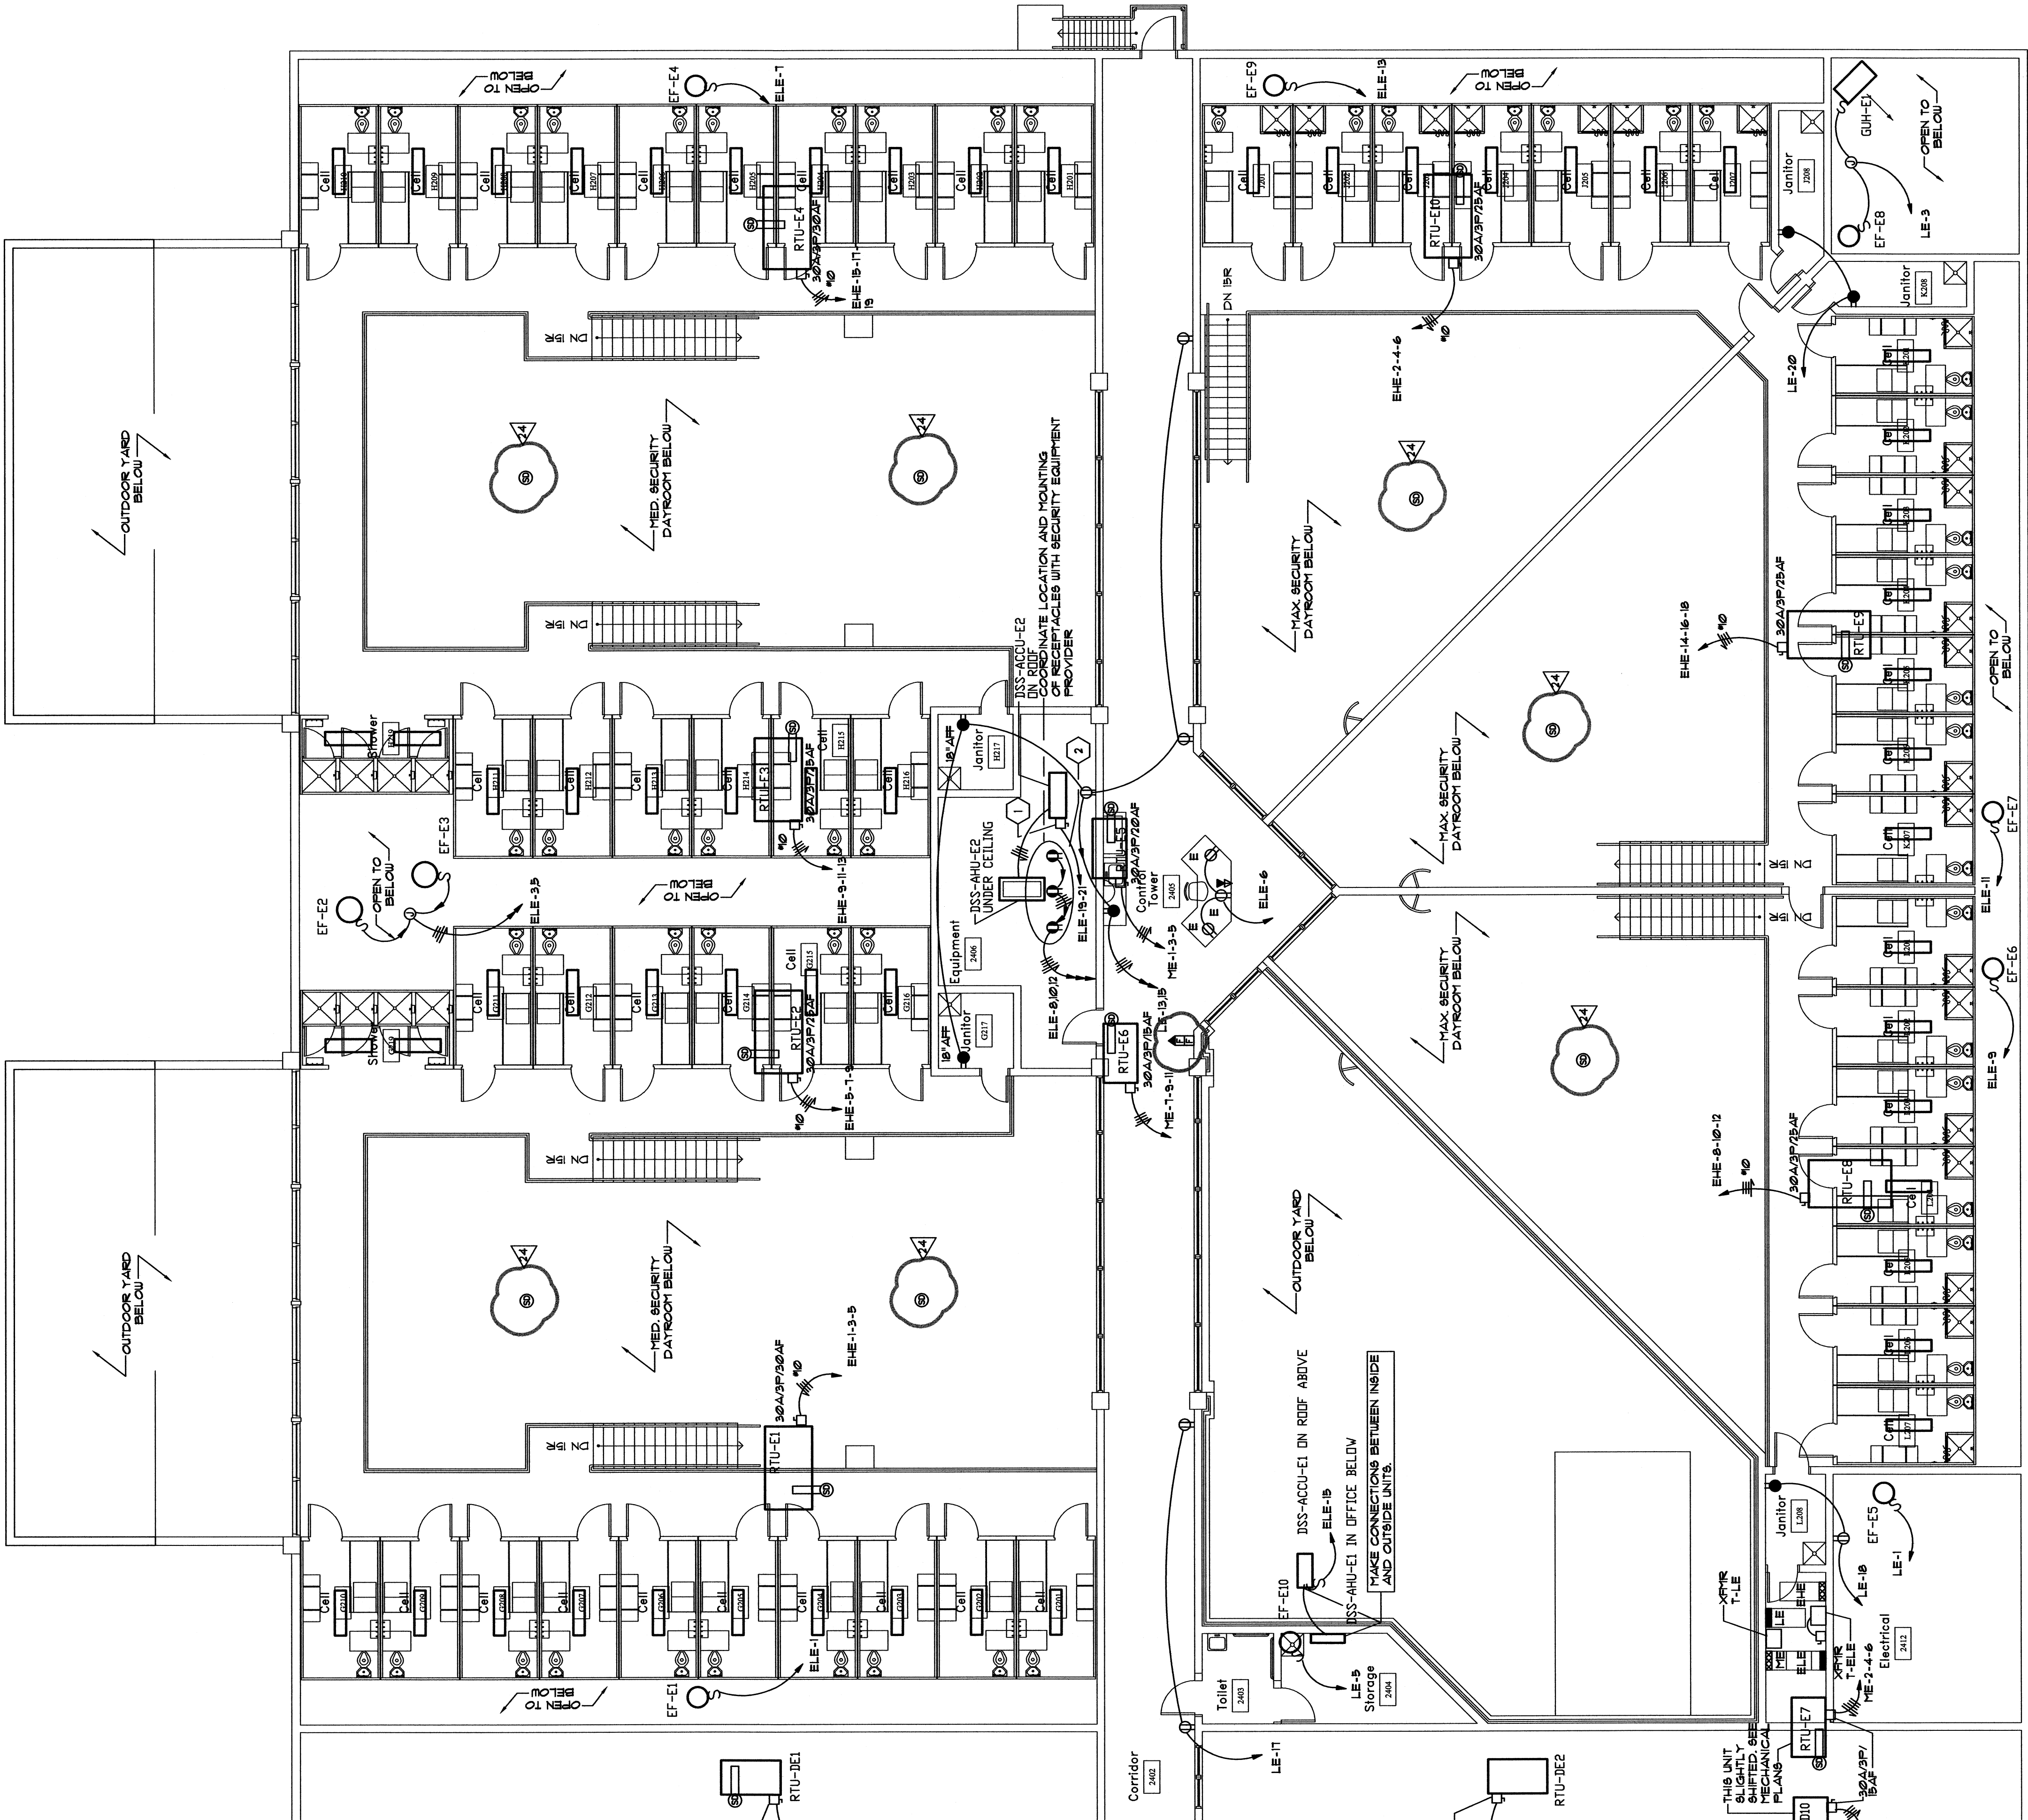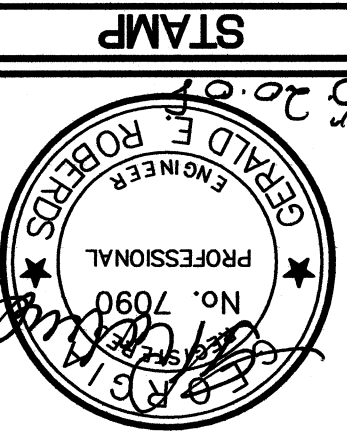

Electrical Plan Area 'E' - Mezzanine