


The information hereon is property of Stanley Security Solutions, Integrator.com Division and shall not be transmitted, copied, or used for purposes other than that for which it was intended.

STANLEY
integrator.com
14670 Cumberland Road
Noblesville, Indiana 46060
Phone (317) 776-3500 Fax (317) 776-3510
www.integrator.com

STANLEY
Security Solutions

TITLE	
JACKSON COUNTY JAIL	
JEFFERSON, GA	
POWER DISTRIBUTION	
JOB #:	JOB DATE:
V.1666	2/25/2008
APPROVAL:	APPROVAL DATE:
JB	
DESIGN:	BRANDEN FRY
SOFTWARE:	CHRIS MARLOW
PROJECT MANAGER:	JASON BRYAN
REVISIONS	
DESCRIPTION	BY/DATE
1	
2	
3	
4	
5	
6	
FILENAME: JCGA-101.2.DWG	
DWG NO.	
ES101.2	

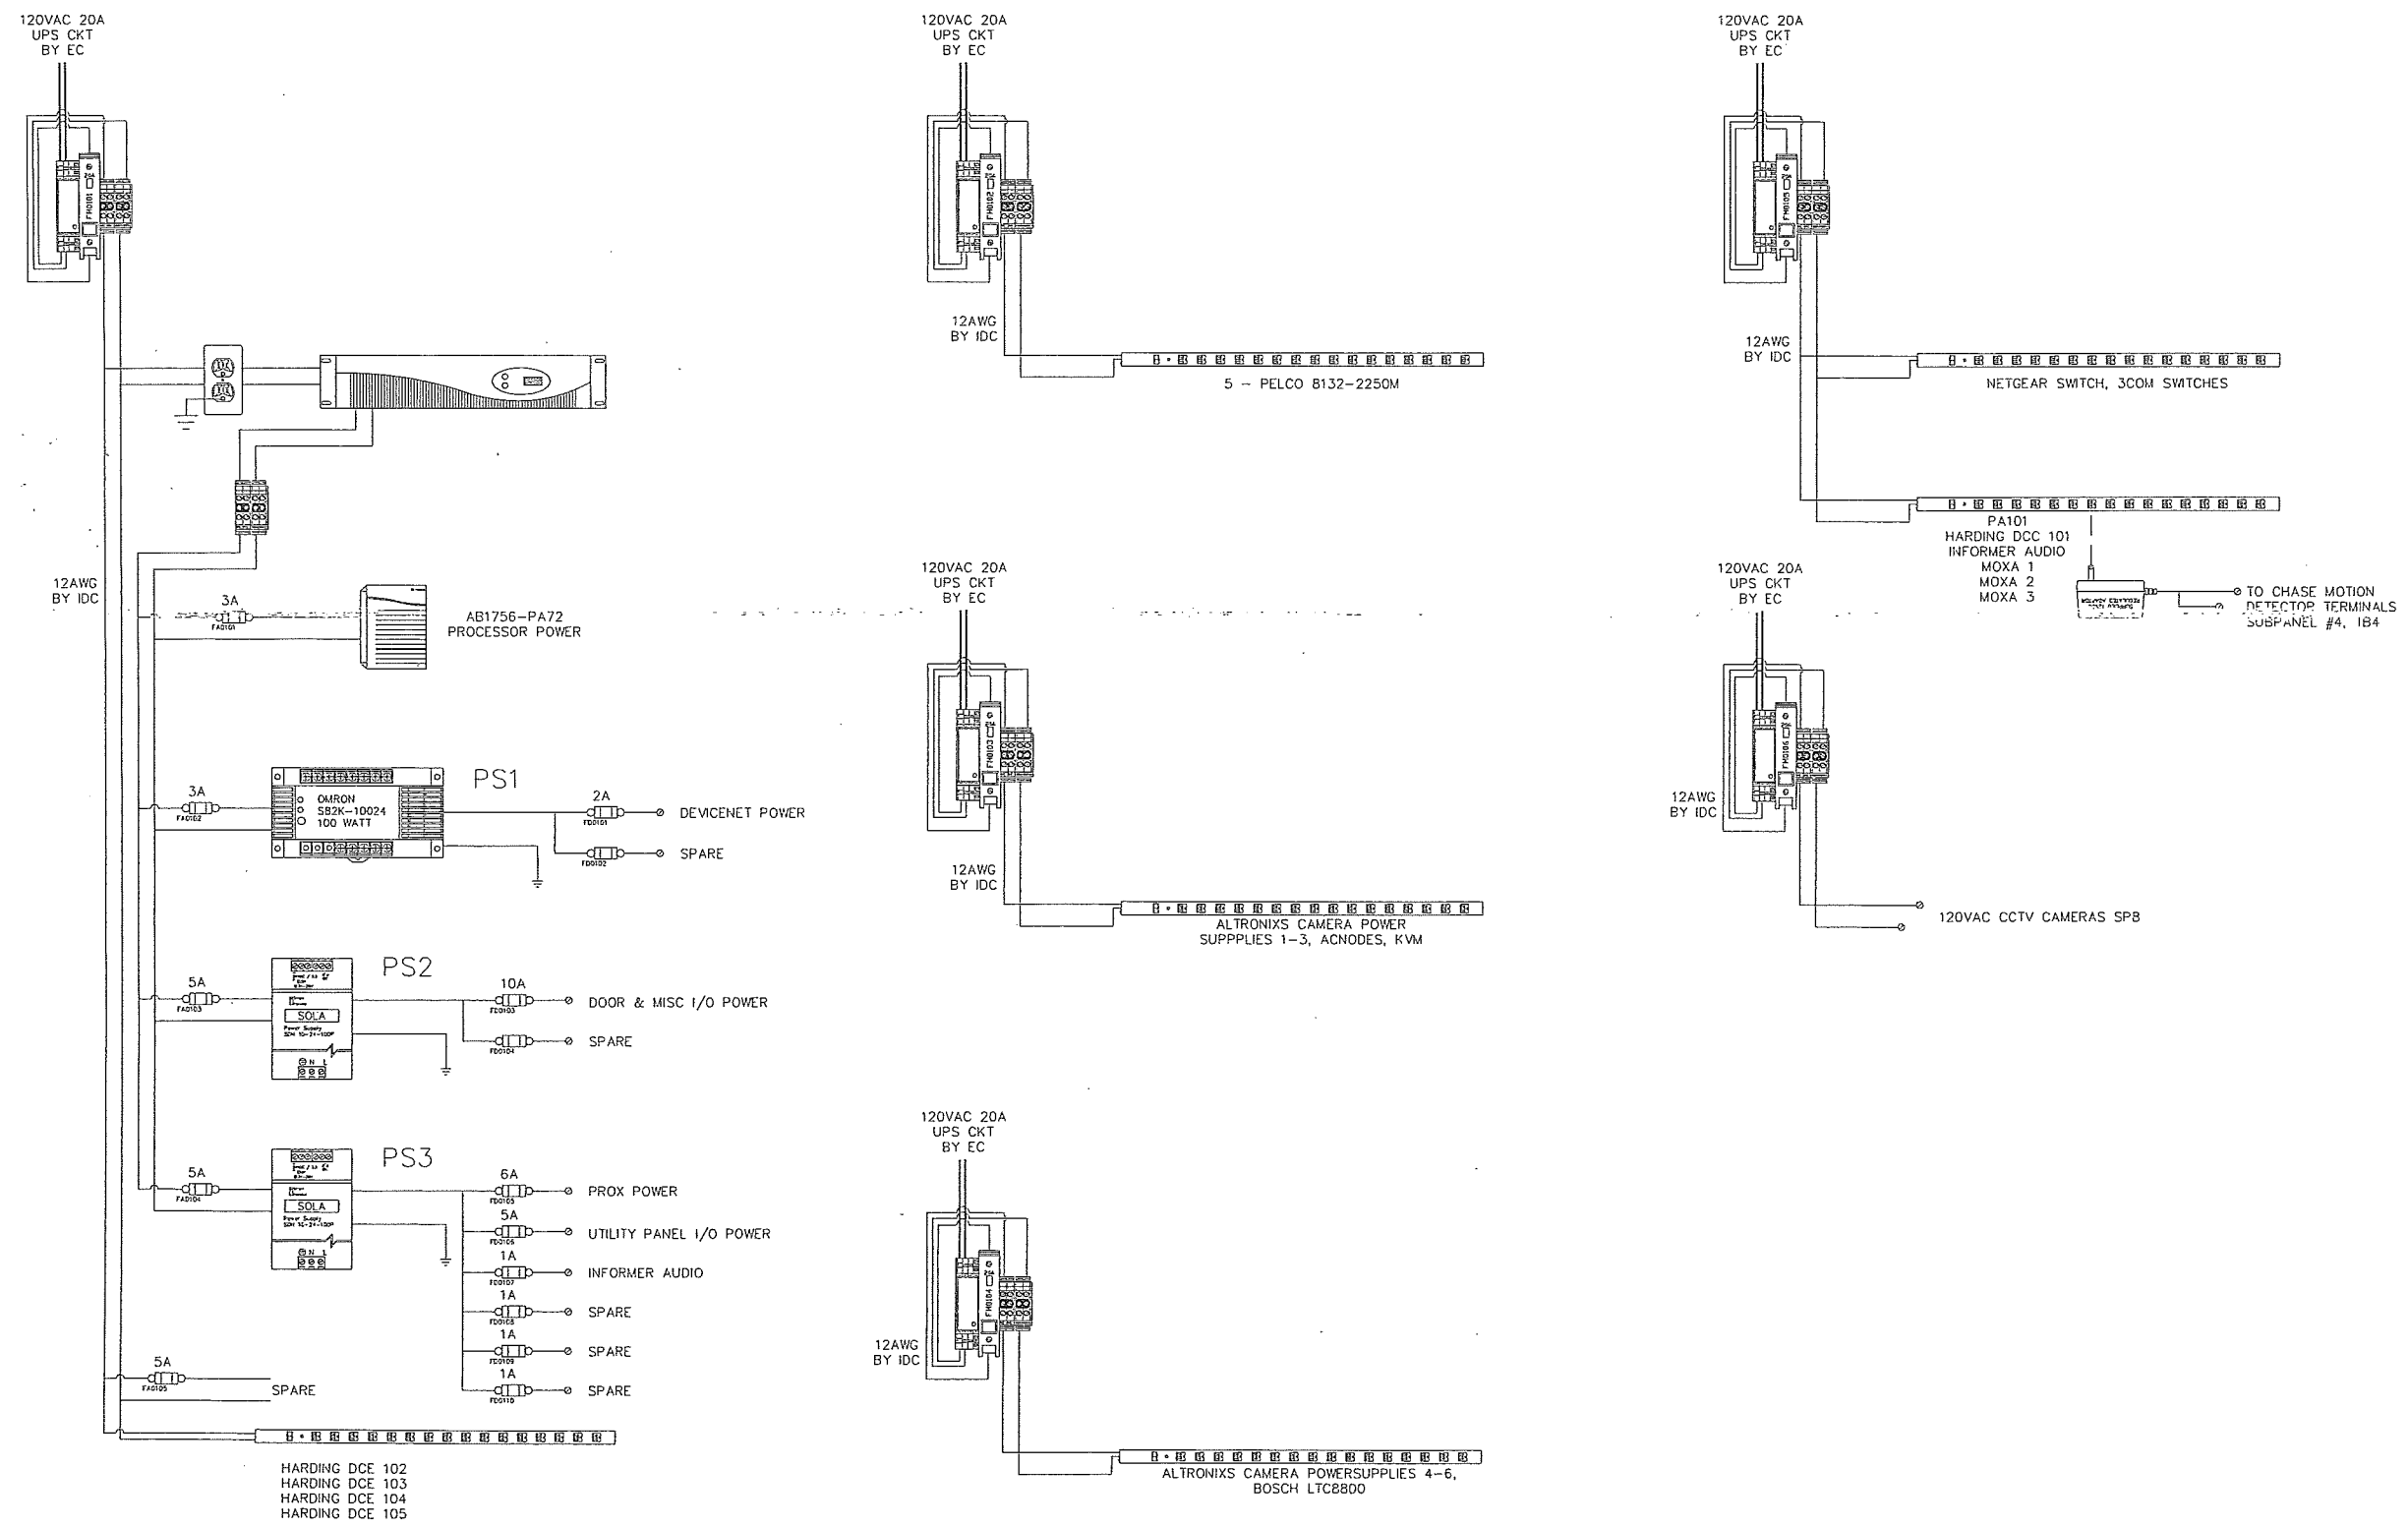

SEC1 EM POWER DISTRIBUTION

The information hereon is property of Stanley Security Solutions, integrator.com Division and shall not be transmitted, copied, or used for purposes other than that for which it was intended.

STANLEY
integrator.com
14670 Cumberland Road
Noblesville, Indiana 46060
Phone: (317) 776-3300 Fax: (317) 776-3510
www.integrator.com

STANLEY
Security Solutions

TITLE
JACKSON COUNTY JAIL

JEFFERSON, GA

POWER DISTRIBUTION

JOB #:	V.1666	JOB DATE:	2/25/2008
APPROVAL:	JB	APPROVAL DATE:	

DESIGN:
BRANDEN FRY

SOFTWARE:
CHRIS MARLOW

PROJECT MANAGER:
JASON BRYAN



REVISIONS

DESCRIPTION	BY/DATE
1	
2	
3	
4	
5	
6	

FILENAME: JCGA-101.3.DWG


DWG NO.

ES101.3

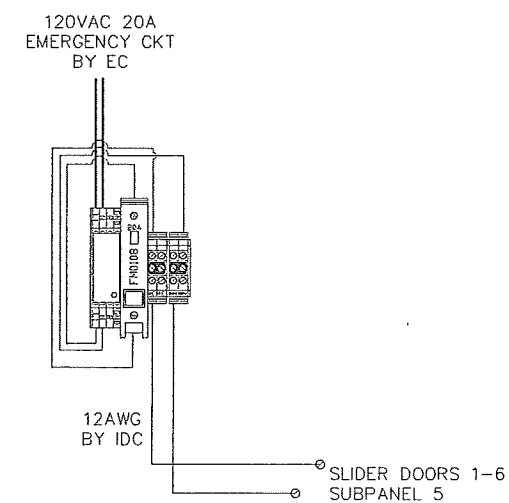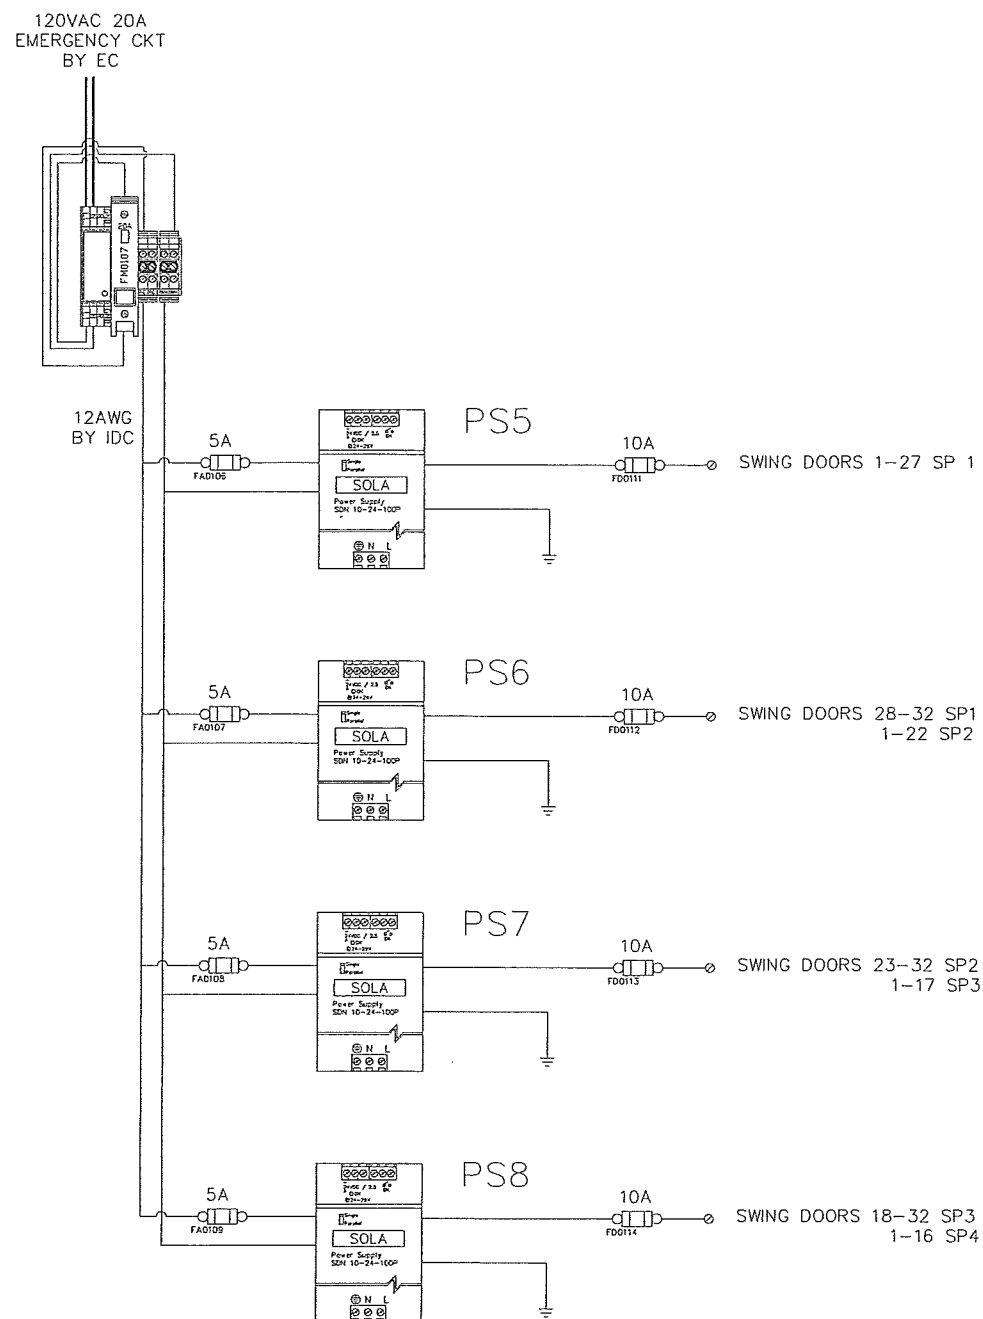


SEC1 EM POWER DISTRIBUTION

FIELD DOOR WIRING
REF. DOOR SCHEDULE

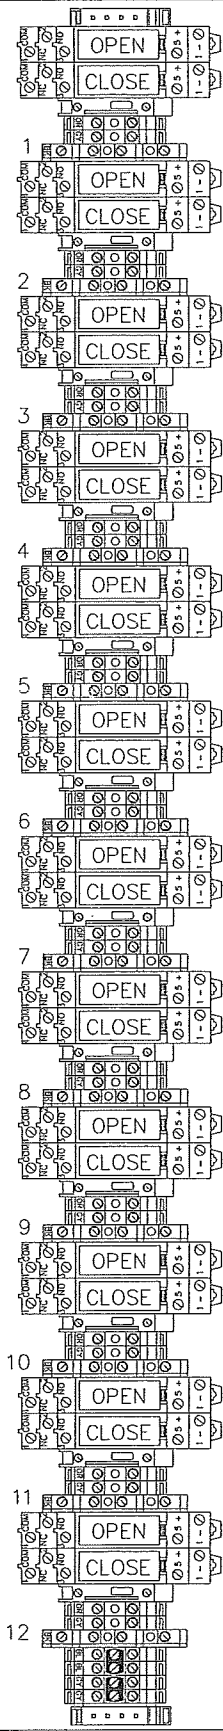

I/O WIRING
SUBPANEL #: 5

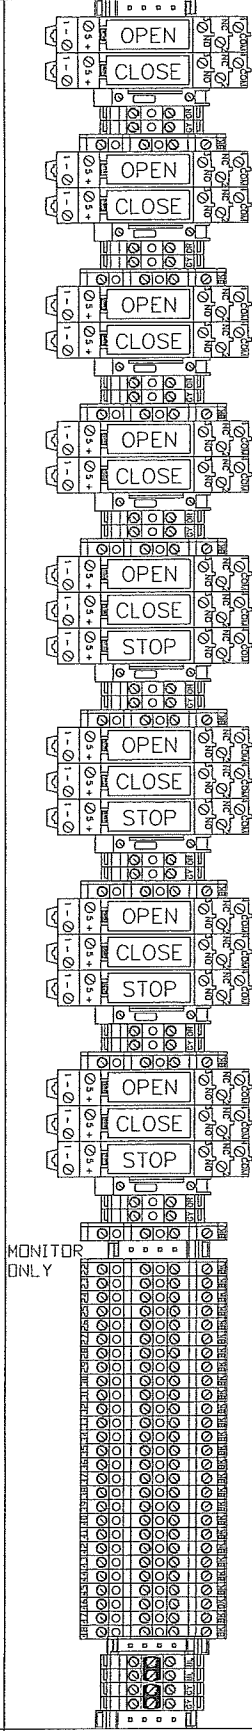

FIELD DOOR WIRING
REF. DOOR SCHEDULE

SEC1 SUBPANEL #5 TERMINAL DETAIL


The information hereon is property of Stanley Security Solutions, integrator.com Division and shall not be transmitted, copied, or used for purposes other than that for which it was intended.

STANLEY
integrator.com
14670 Cumberland Road
Noblesville, Indiana 46060
Phone: (317) 776-5400
www.integrator.com


STANLEY
Security Solutions

TITLE	
JACKSON COUNTY JAIL	
JEFFERSON, GA	
TERMINAL DETAIL	
JOB #:	JOB DATE:
V.1666	2/25/2008
APPROVAL:	APPROVAL DATE:
JB	
DESIGN:	
BRANDEN FRY	
SOFTWARE:	
CHRIS MARLOW	
PROJECT MANAGER:	
JASON BRYAN	
REVISIONS	
DESCRIPTION	BY/DATE
1	
2	
3	
4	
5	
6	
FILENAME: JCGA-101.4.DWG	
DWG NO.	
ES101.4	

FIELD DOOR WIRING
REF. DOOR SCHEDULE


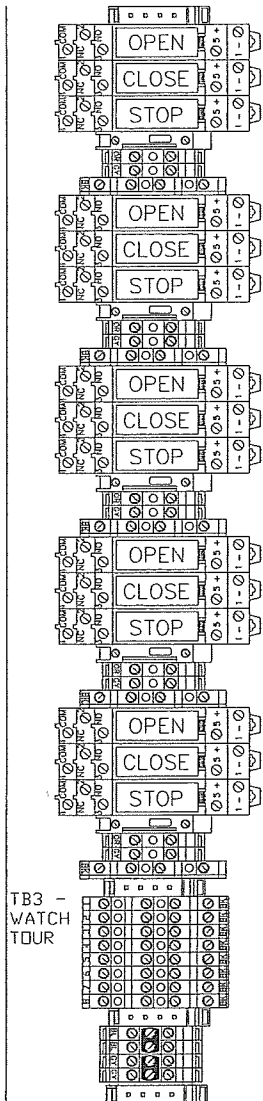


SUBPANEL #: 6 I/O WIRING

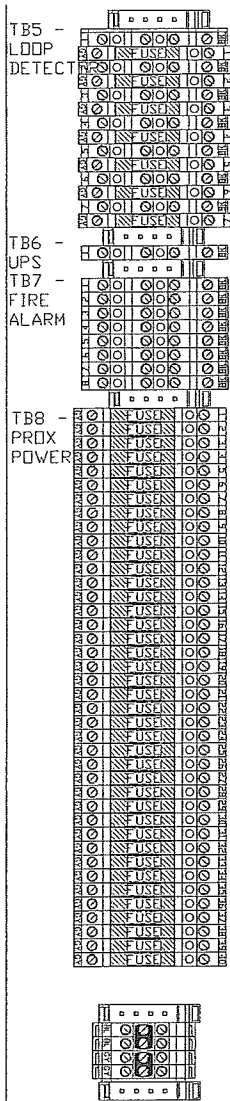

FIELD DOOR WIRING
REF. DOOR SCHEDULE

The information hereon is property of Stanley Security Solutions, integrator.com Division and shall not be transmitted, copied, or used for purposes other than that for which it was intended.

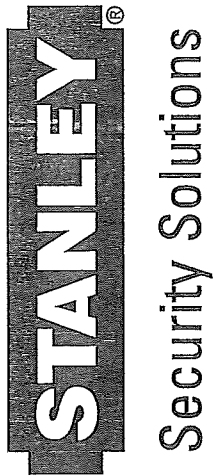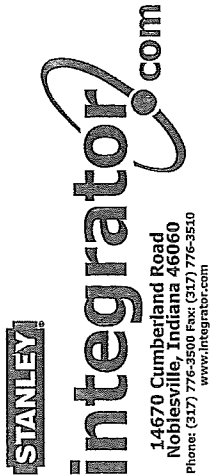

TITLE	
JACKSON COUNTY JAIL	
JEFFERSON, GA	
TERMINAL DETAIL	
JOB #:	JOB DATE:
V.1666	2/25/2008
APPROVAL:	APPROVAL DATE:
JB	
DESIGN:	
BRANDEN FRY	
SOFTWARE:	
CHRIS MARLOW	
PROJECT MANAGER:	
JASON BRYAN	
REVISIONS	
DESCRIPTION	BY/DATE
1	
2	
3	
4	
5	
6	
FILENAME: JCGA-101.5.DWG	
DWG NO.	
ES101.5	

The information hereon is property of Stanley Security Solutions, integrator.com Division and shall not be transmitted, copied, or used for purposes other than that for which it was intended.

STANLEY
integrator.com
14570 Cumberland Road
Noblesville, Indiana 46060
Phone: (317) 776-3500 Fax: (317) 776-3510
www.integrator.com

STANLEY
Security Solutions

TITLE
JACKSON COUNTY JAIL

JEFFERSON, GA

TERMINAL DETAIL

JOB #:	V.1666	JOB DATE:	2/25/2008
APPROVAL:	JB	APPROVAL DATE:	

DESIGN: BRANDEN FRY

SOFTWARE: CHRIS MARLOW

PROJECT MANAGER: JASON BRYAN


REVISIONS

DESCRIPTION	BY/DATE
1	
2	
3	
4	
5	
6	

FILENAME: JCGA-101.6.DWG


DWG NO.

ES101.6

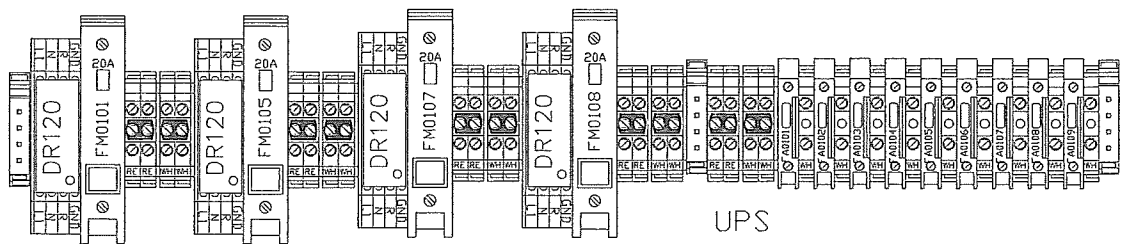


UPS

SUBPANEL #: 7

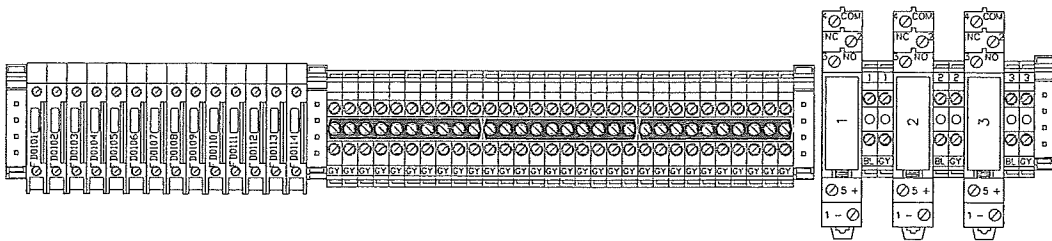

TB9 PHONE RELAY

PROX READER
SURGE PROTECTOR

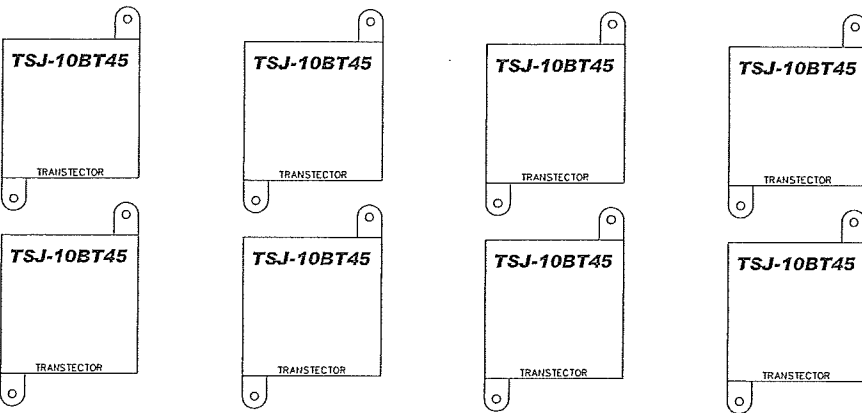

PHONE RELAYS


SEC1 SUBPANEL #7 TERMINAL DETAIL

The information hereon is property of Stanley Security Solutions, integrator.com Division and shall not be transmitted, copied, or used for purposes other than that for which it was intended.

STANLEY
integrator.com
14670 Cumberland Road
Noblesville, Indiana 46060
Phone: (317) 776-3500 Fax: (317) 776-3510
www.integrator.com

STANLEY
Security Solutions

TITLE	
JACKSON COUNTY JAIL	
JEFFERSON, GA	
TERMINAL DETAIL	
JOB #:	JOB DATE:
V.1666	2/25/2008
APPROVAL:	APPROVAL DATE:
JB	
DESIGN:	
BRANDEN FRY	
SOFTWARE:	
CHRIS MARLOW	
PROJECT MANAGER:	
JASON BRYAN	
REVISIONS	
DESCRIPTION	BY/DATE
1	
2	
3	
4	
5	
6	
FILENAME: JCGA-101.7.DWG	
DWG NO.	
ES101.7	

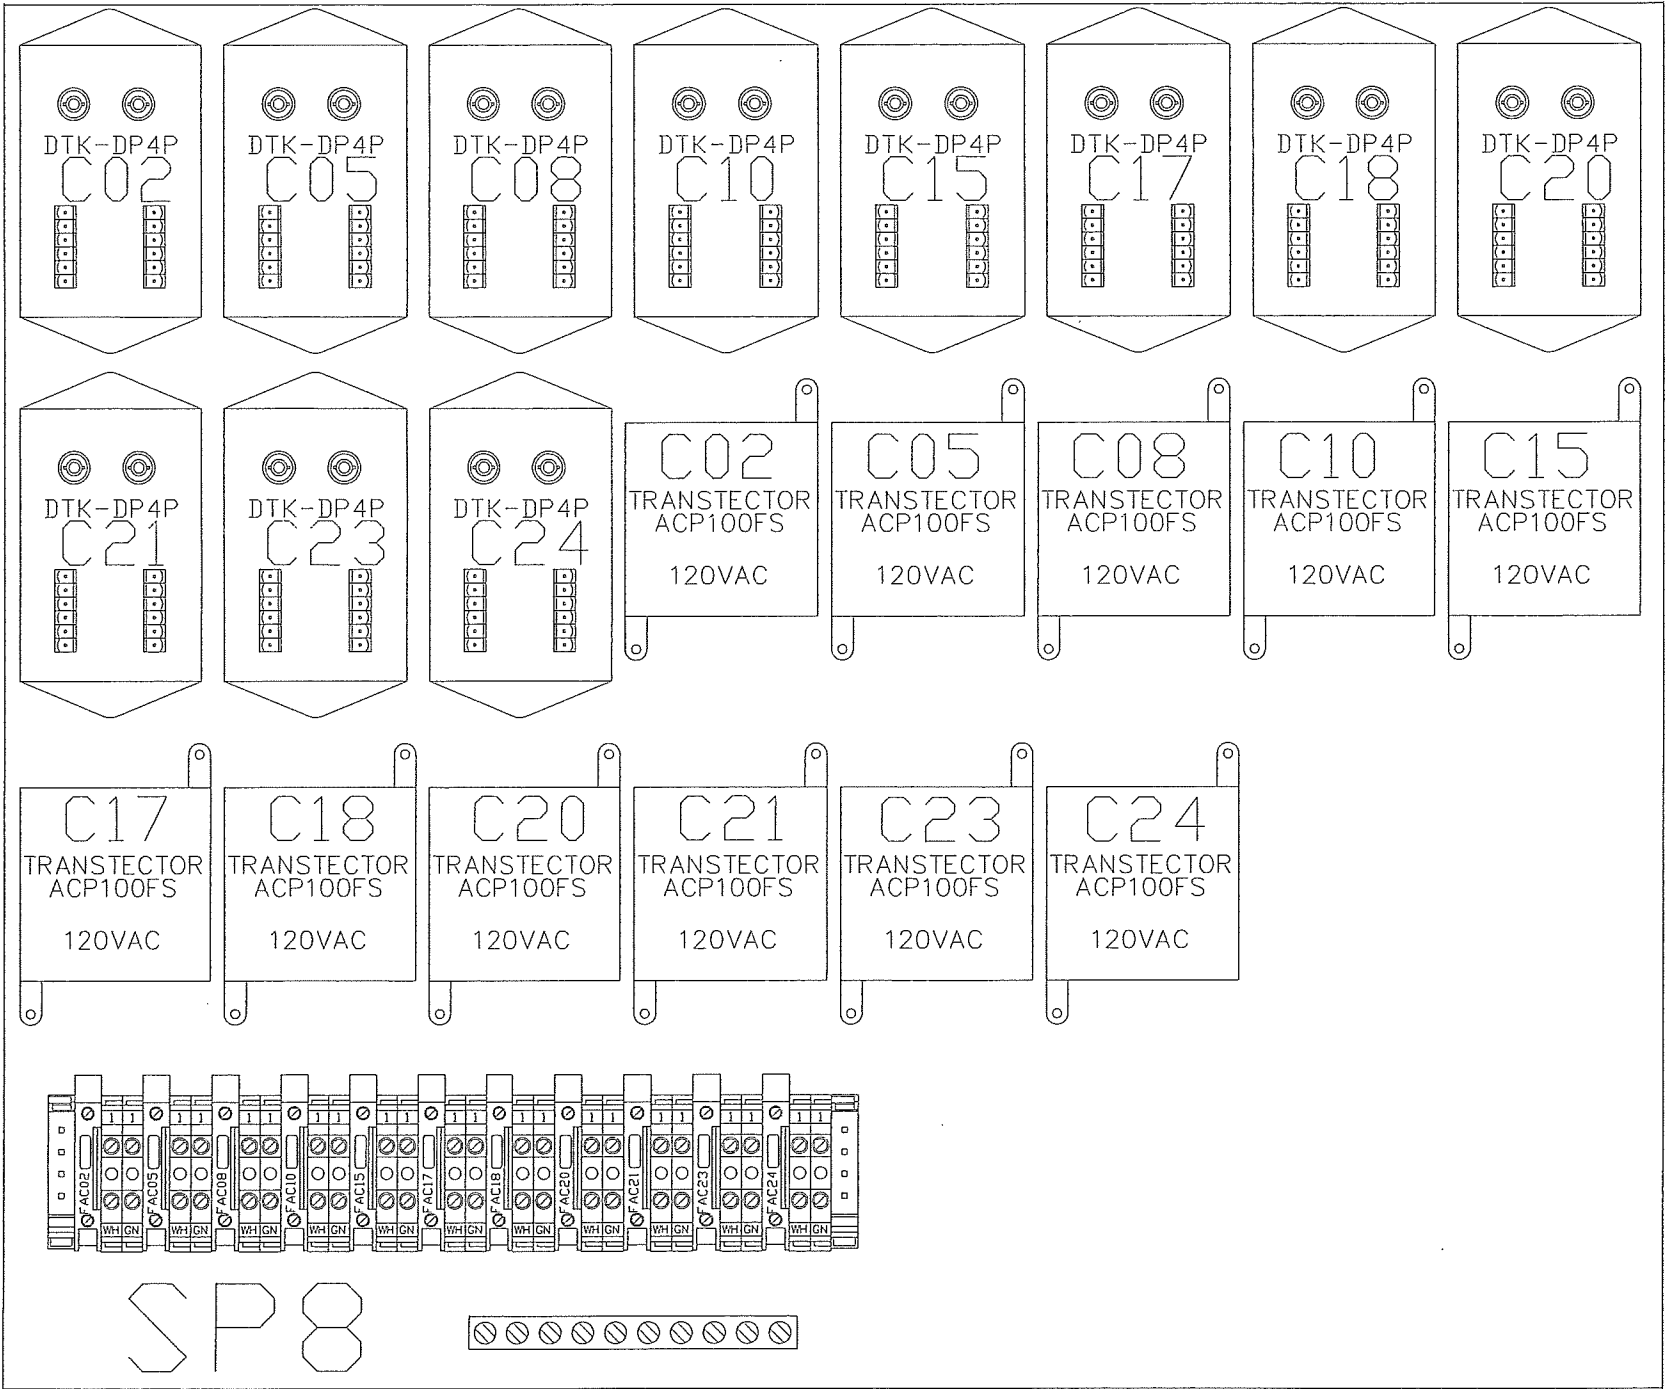

SEC1 SUBPANEL #8 TERMINAL DETAIL

The information hereon is property of Stanley Security Solutions, Integrator.com Division and shall not be transmitted, copied, or used for purposes other than that for which it was intended.

STANLEY
integrator.com
14670 Cumberland Road
Noblesville, Indiana 46060
Phone: (317) 776-3500 Fax: (317) 776-3510
www.integrator.com

STANLEY
Security Solutions

TITLE
JACKSON COUNTY JAIL
JEFFERSON, GA
TERMINAL DETAIL

JOB #:	V.1666	JOB DATE:	2/25/2008
APPROVAL:	JB	APPROVAL DATE:	

DESIGN: BRANDEN FRY

SOFTWARE: CHRIS MARLOW

PROJECT MANAGER: JASON BRYAN


REVISIONS

DESCRIPTION	BY/DATE
1	
2	
3	
4	
5	
6	


FILENAME: JCGA-101.8.DWG

DWG NO.

ES101.8

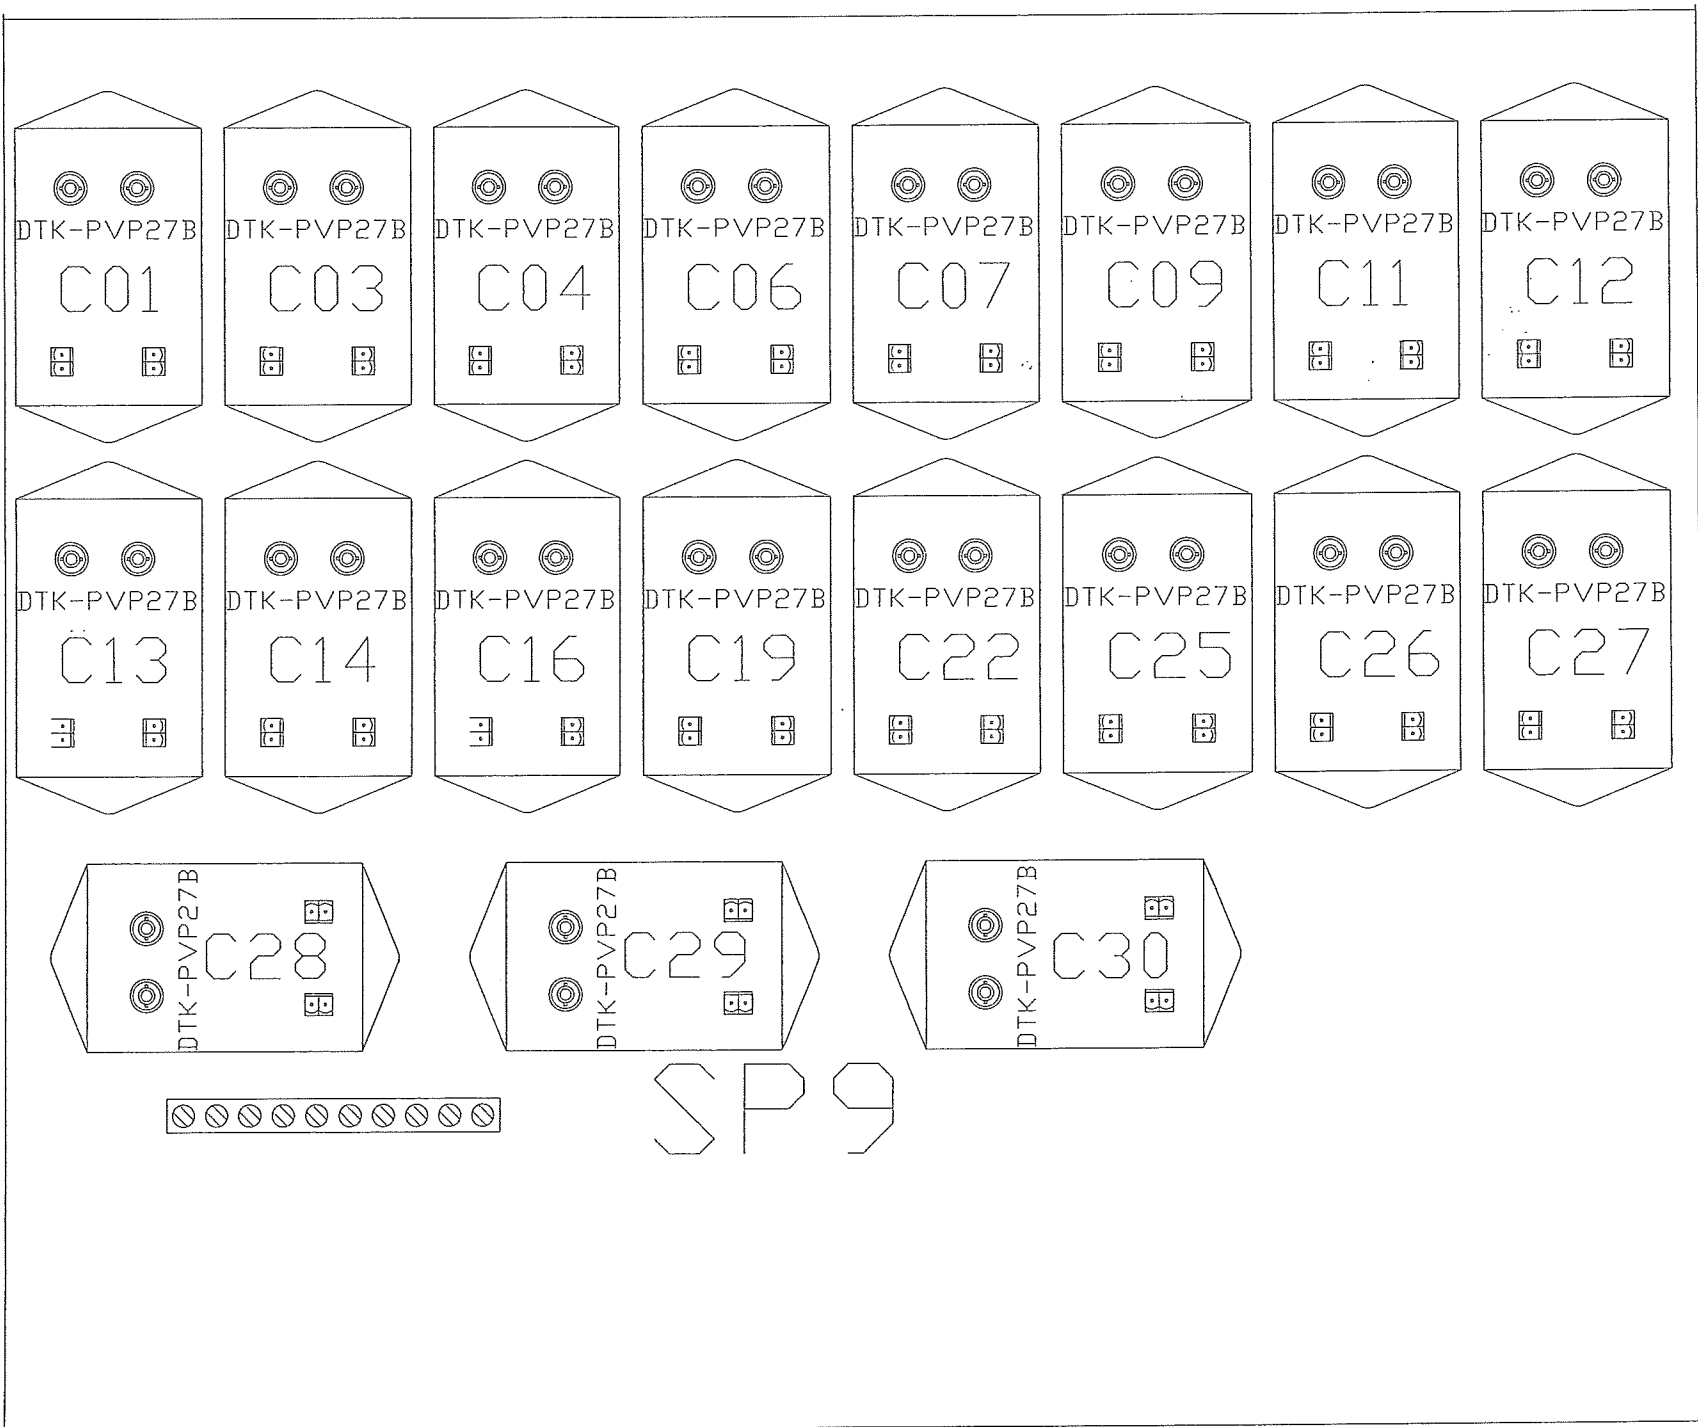

SEC1 SUBPANEL #9 TERMINAL DETAIL

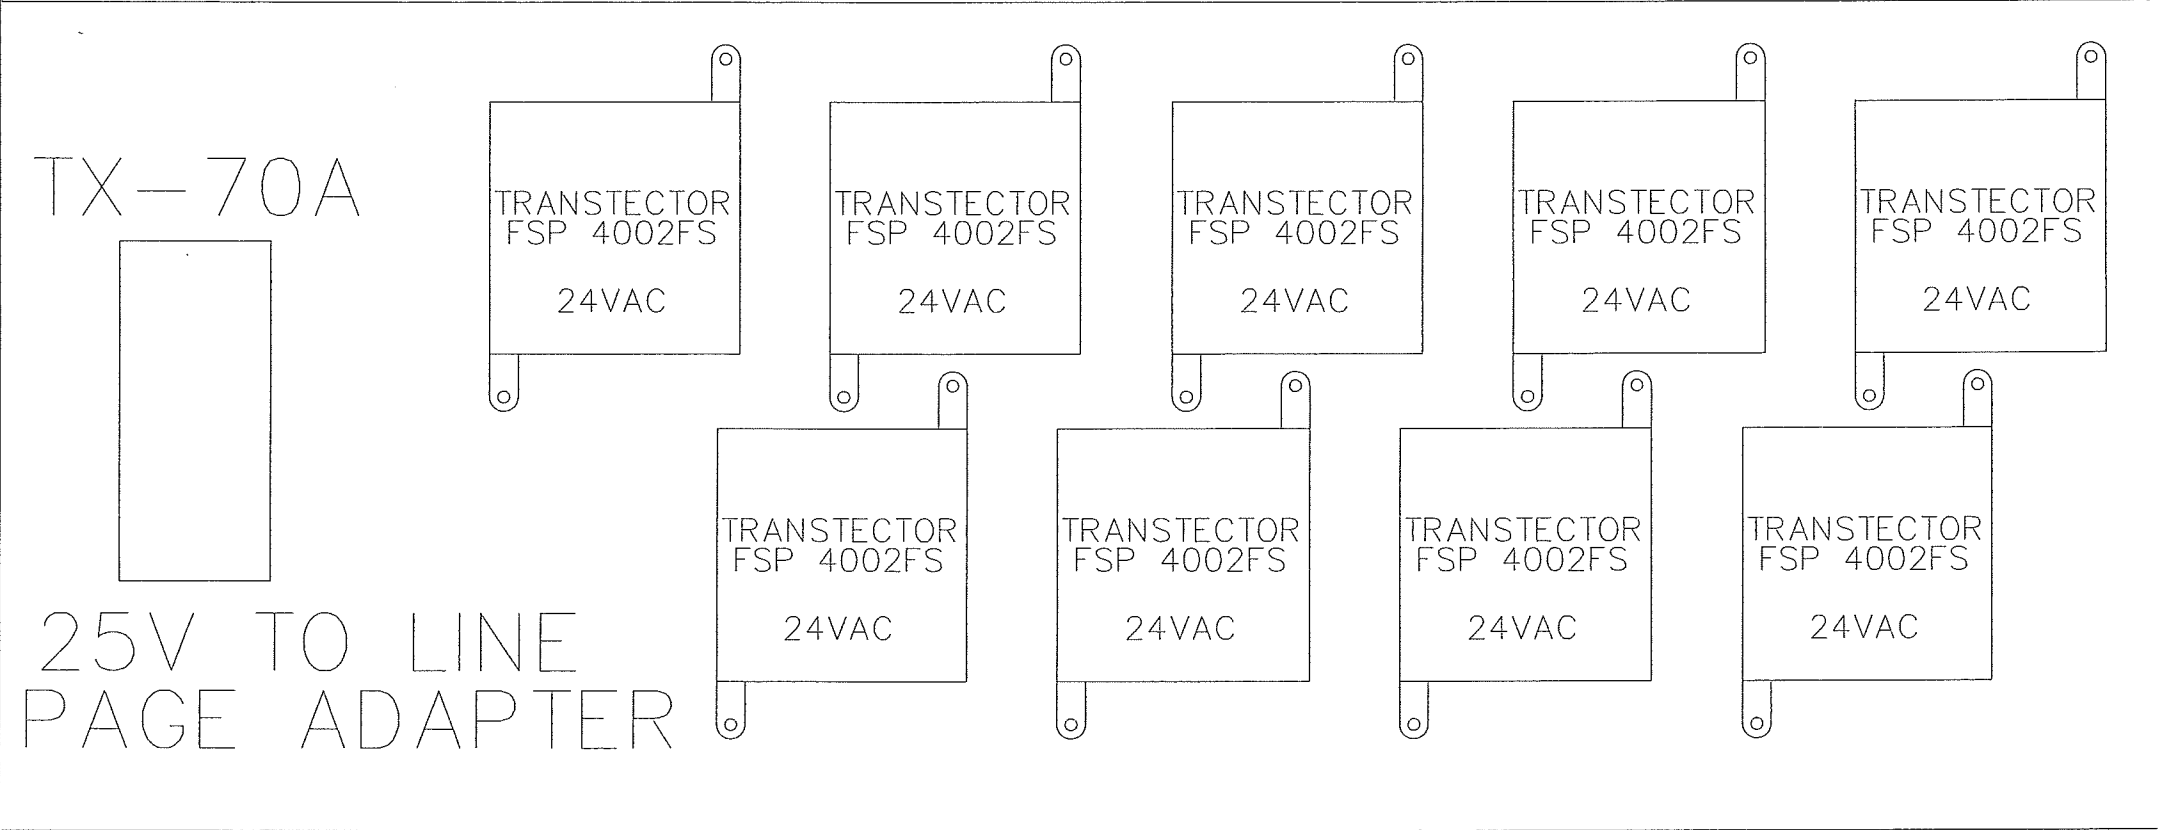


The information hereon is property of Stanley Security Solutions, integrator.com Division and shall not be transmitted, copied, or used for purposes other than that for which it was intended.

STANLEY
integrator.com
14670 Cumberland Road
Noblesville, Indiana 46060
Phone: (317) 776-3500 Fax: (317) 776-3510
www.integrator.com

STANLEY
Security Solutions

TITLE	
JACKSON COUNTY JAIL	
JEFFERSON, GA	
TERMINAL DETAIL	
JOB #:	JOB DATE:
V.1666	2/25/2008
APPROVAL:	APPROVAL DATE:
JB	
DESIGN:	
BRANDEN FRY	
SOFTWARE:	
CHRIS MARLOW	
PROJECT MANAGER:	
JASON BRYAN	
REVISIONS	
DESCRIPTION	BY/DATE
1	
2	
3	
4	
5	
6	
FILENAME: JCGA-101.9.DWG	
DWG NO.	
ES101.9	

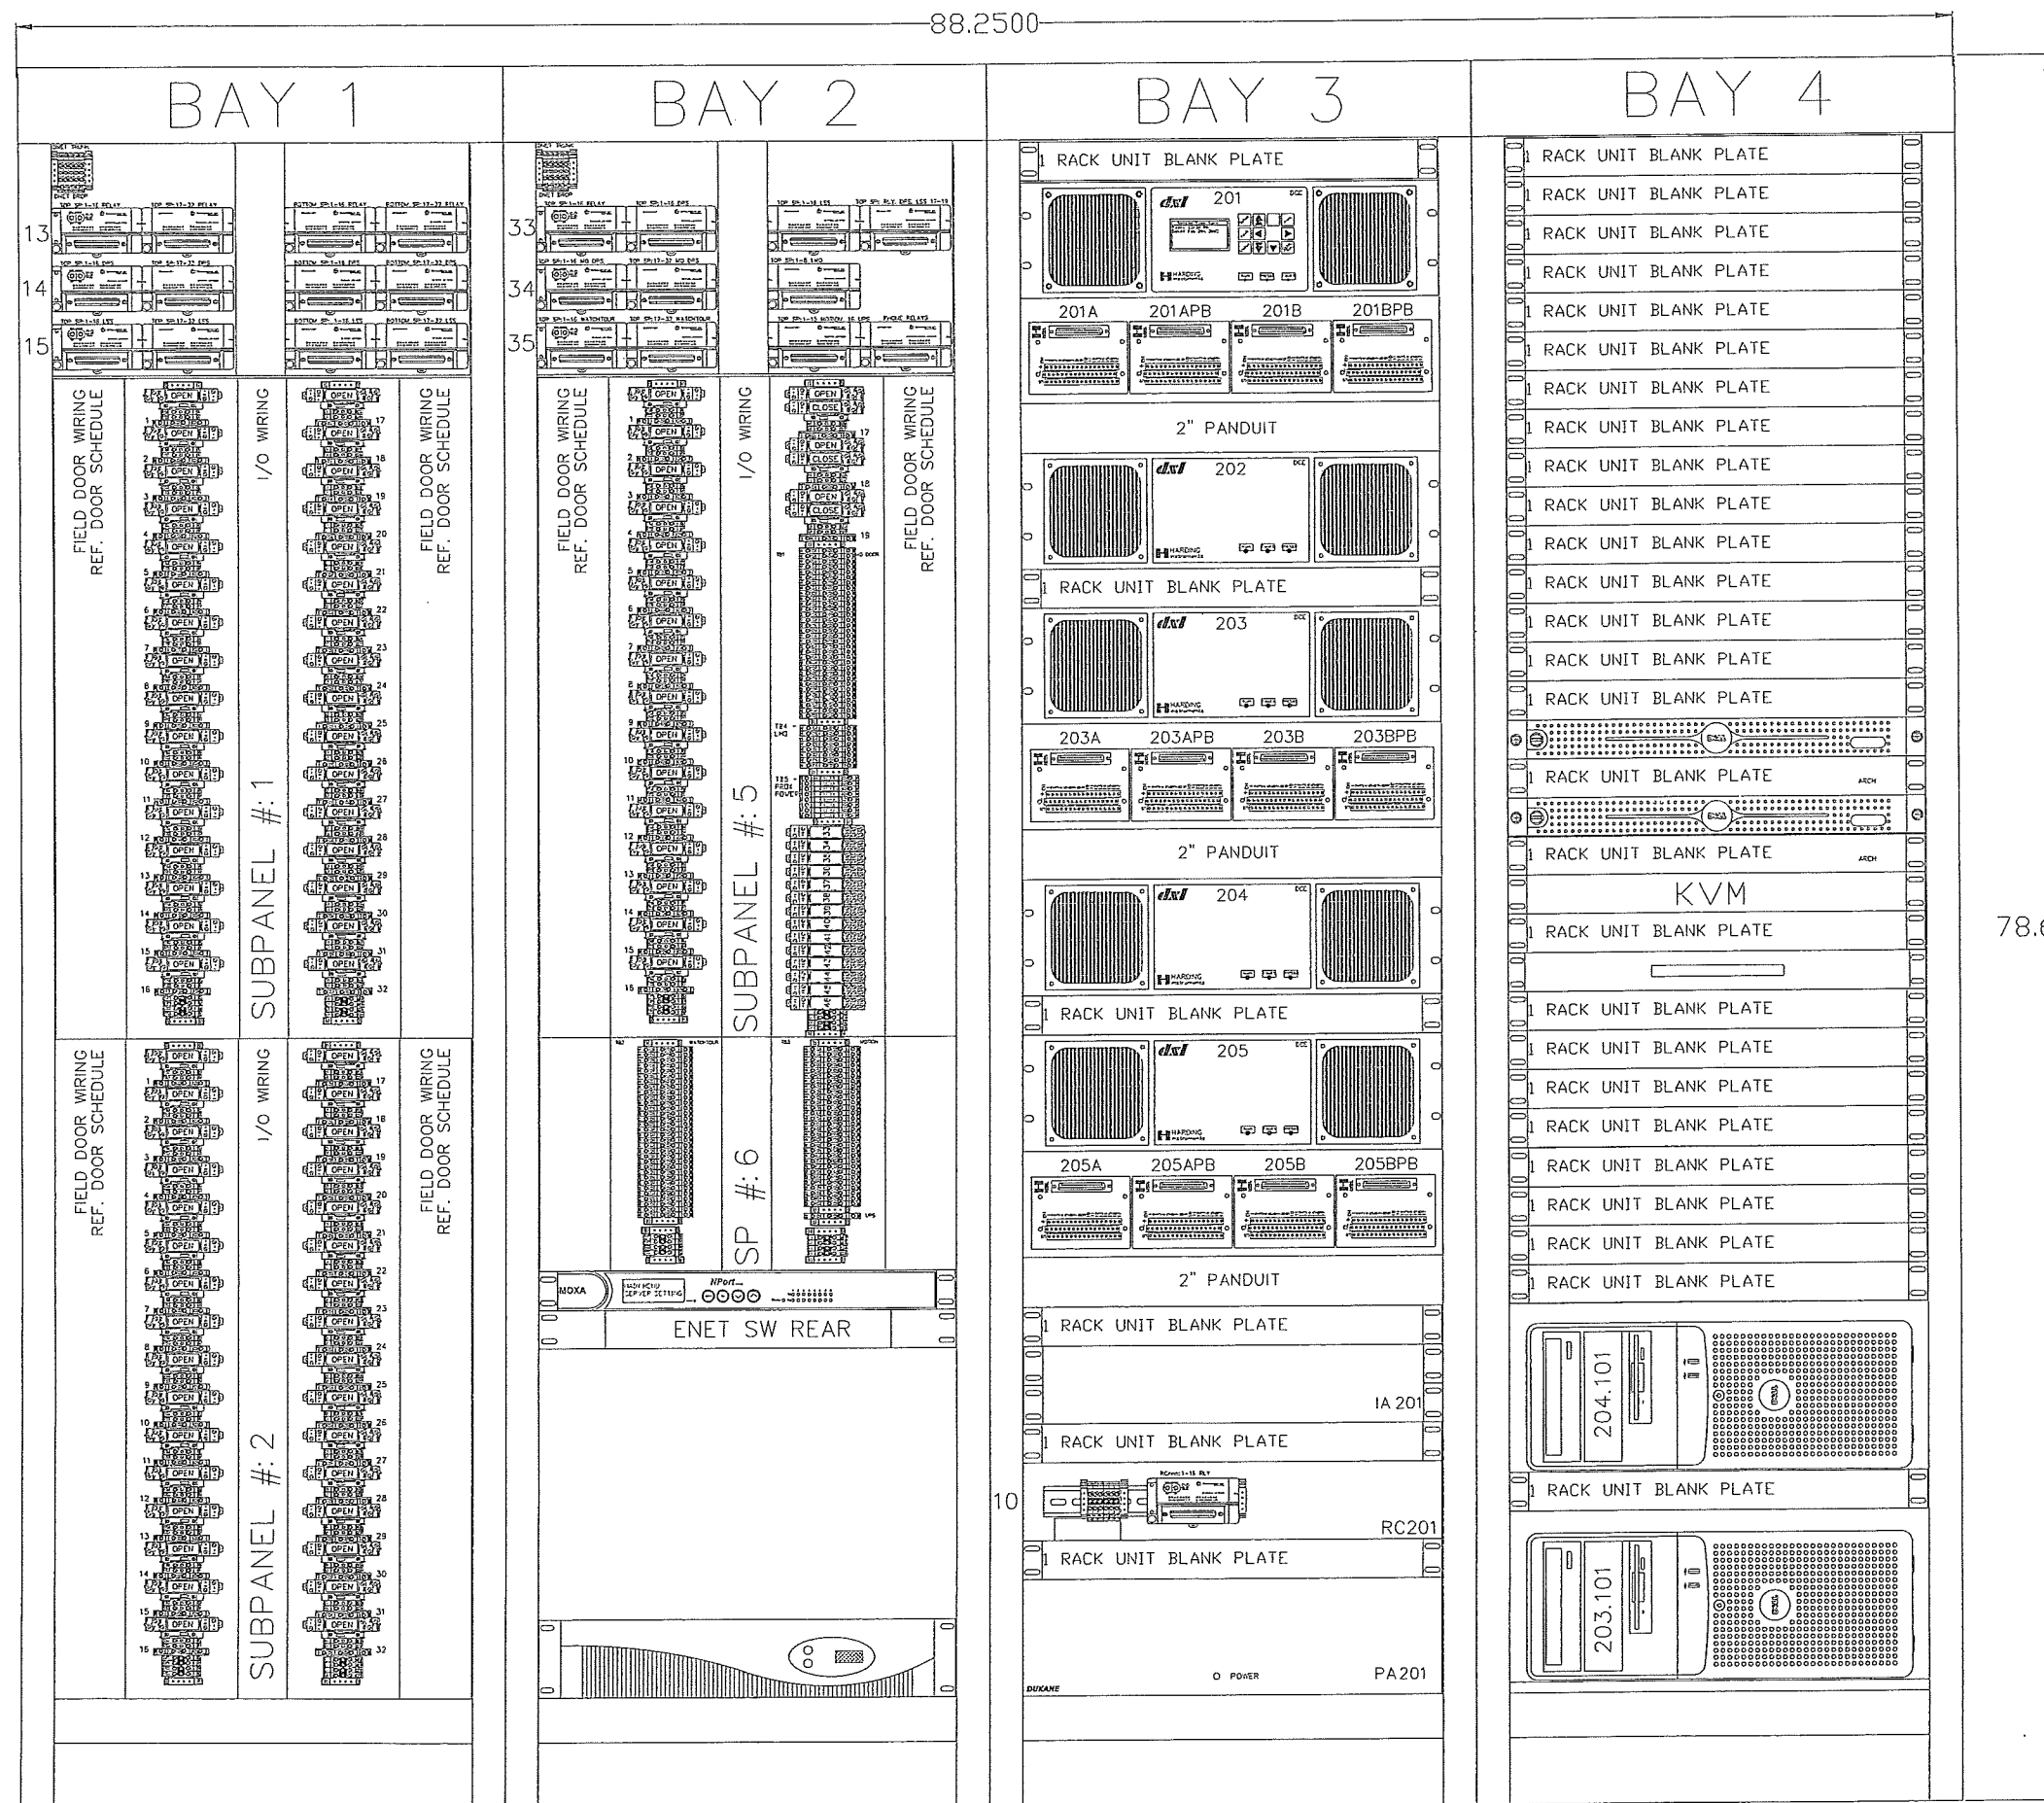

SPLIT FOR SHIPPING

SEC2 CABINET LAYOUT - FRONT

The information hereon is property of Stanley Security Solutions, Integrator.com Division and shall not be transmitted, copied, or used for purposes other than that for which it was intended.

STANLEY
integrator.com
14670 Cumberland Road
Noblesville, Indiana 46060
Phone: (317) 776-3500 Fax: (317) 776-3510
www.integrator.com

STANLEY
Security Solutions

TITLE
JACKSON COUNTY JAIL
JEFFERSON, GA
CABINET LAYOUT

JOB #: V.1666
JOB DATE: 2/25/2008
APPROVAL: JB
APPROVAL DATE:

DESIGN: BRANDEN FRY

SOFTWARE: CHRIS MARLOW

PROJECT MANAGER: JASON BRYAN


REVISIONS

DESCRIPTION	BY/DATE
⚠	
⚠	
⚠	
⚠	
⚠	
⚠	

FILENAME: JCGA-102.0.DWG

DWG NO.

ES102.0

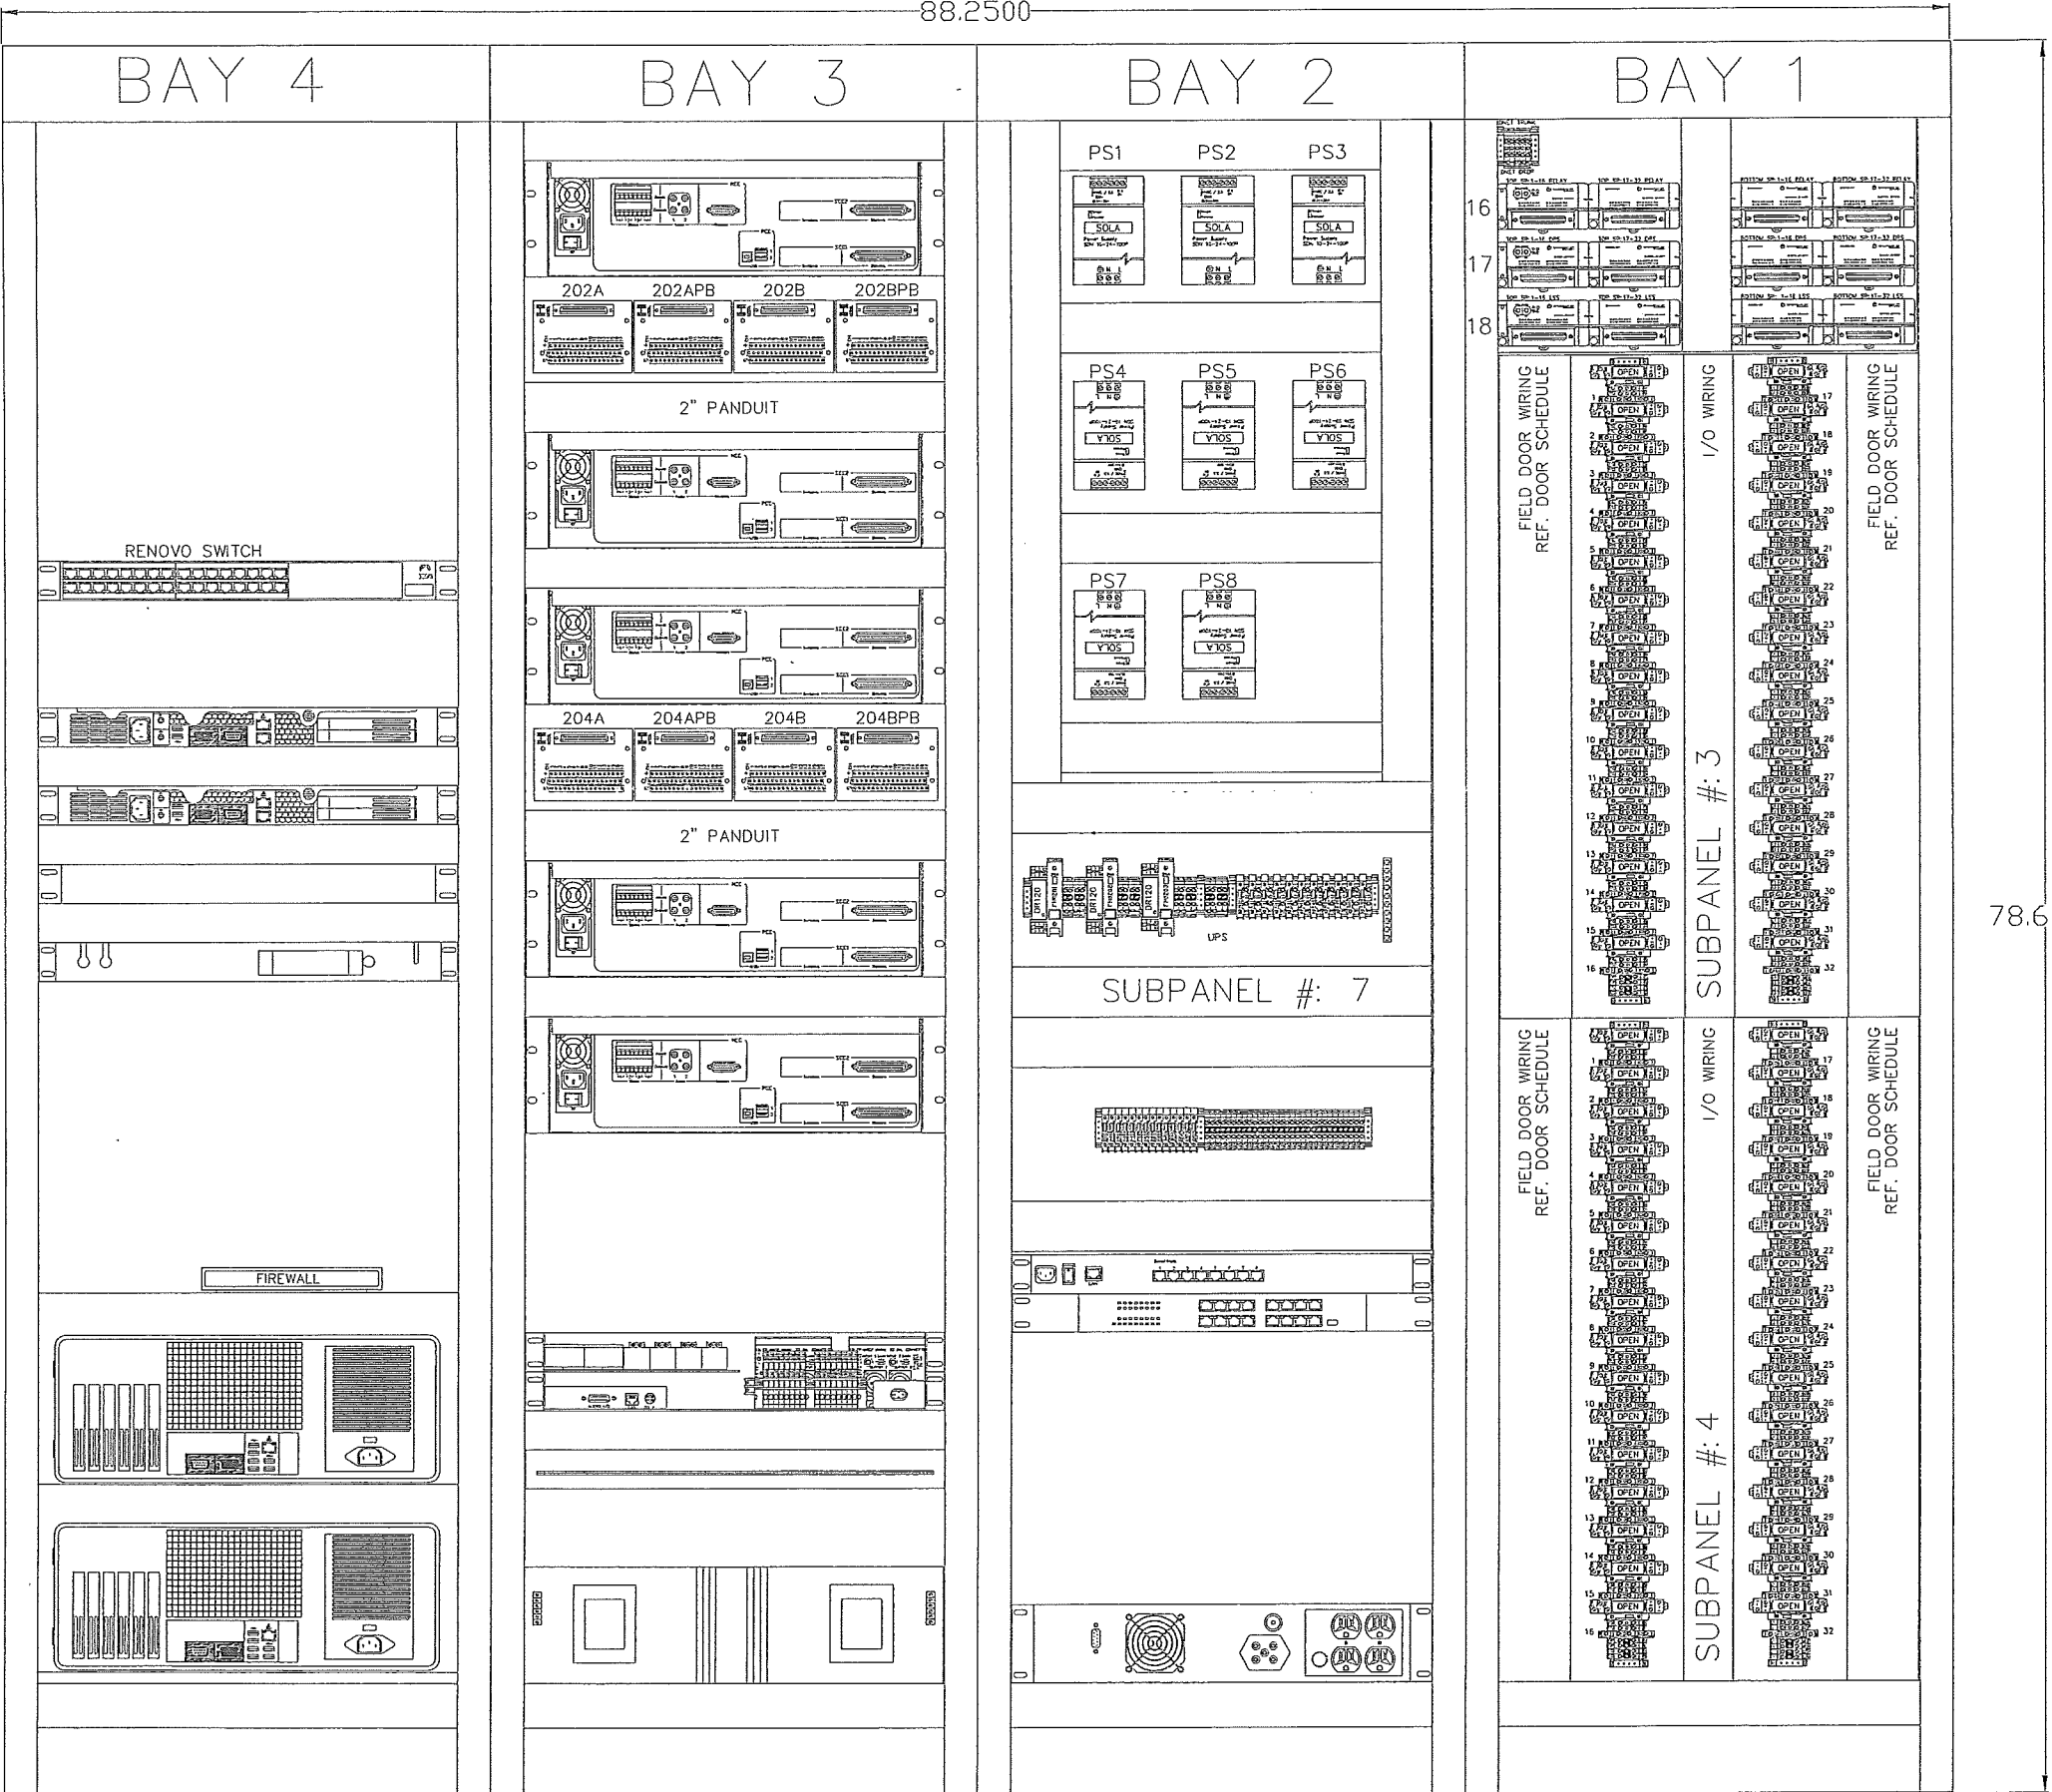

88.2500

78.6250

SPLIT FOR SHIPPING

The information hereon is property of Stanley Security Solutions, Integrator.com Division and shall not be transmitted, copied, or used for purposes other than that for which it was intended.


STANLEY
integrator.com
14570 Cumberland Road
Noblesville, Indiana 46060
Phone: (317) 776-3500 Fax: (317) 776-3510
www.integrator.com

STANLEY
Security Solutions


TITLE	
JACKSON COUNTY JAIL	
JEFFERSON, GA	
CABINET LAYOUT	
JOB #: V.1666	JOB DATE: 2/25/2008
APPROVAL: JB	APPROVAL DATE:
DESIGN: BRANDEN FRY	
SOFTWARE: CHRIS MARLOW	
PROJECT MANAGER: JASON BRYAN	
REVISIONS	
DESCRIPTION	BY/ DATE
1	
2	
3	
4	
5	
6	
FILENAME: JCGA-102.1.DWG	
DWG NO.	
ES102.1	

SEC2 CABINET LAYOUT - REAR

1 - 20A 120VAC
UPS SERVICE (BY E.C.)

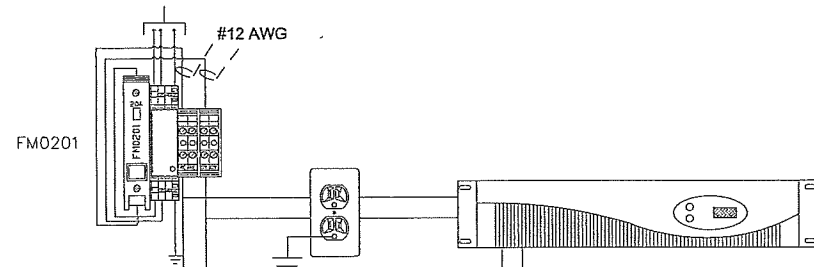

1 - 20A 120VAC
UPS SERVICE (BY E.C.)

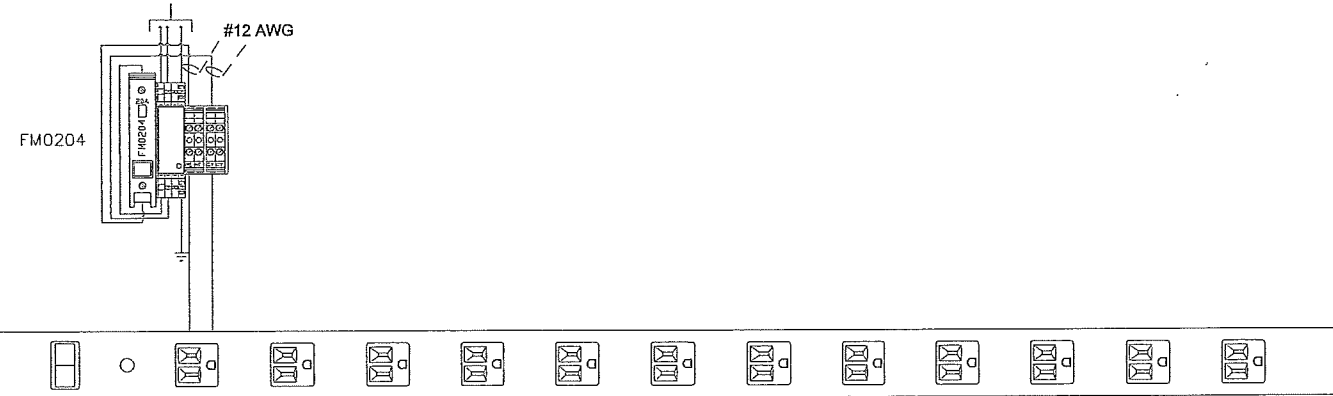

FA0201 5A

PS1

FA0202 5A

PS2

DC COMMON

FD0201 6A DOOR / MISC. I/O POWER

FD0202 2A PROX POWER

FD0203 2A SPARE

FD0204 1A SPARE

DC COMMON

FD0205 4A SPARE

FD0206 2A SPARE

FD0207 1A INFORMER AUDIO

FD0208 6A UTILITY I/O POWER

FA0203 2A SPARE

FA0204 2A SPARE

ETHERNET SWITCH

PAGE AMP

INFORMER AUDIO

MOXA

HARDING DCC 201

HARDING DOE 202

HARDING DOE 203

HARDING DOE 204

HARDING DOE 205

TO CHASE MOTION
DETECTOR TERMINALS
TB3

TCSS1

TCSS2

SG - FIREWALL

RENOVO SERVER

RENOVO SERVER

ACNODES

KVM

3COM ENET SWITCH

The information hereon is
property of Stanley Security
Solutions, integrator.com
Division and shall not be
transmitted, copied, or used for
purposes other than that for
which it was intended.

STANLEY
integrator.com
14670 Cumberland Road
Noblesville, Indiana 46060
Phone: (317) 776-3500 Fax: (317) 776-3510
www.integrator.com

STANLEY
Security Solutions

TITLE
JACKSON COUNTY JAIL

JEFFERSON, GA

POWER DISTRIBUTION

JOB #: V.1666 JOB DATE: 2/25/2008
APPROVAL: JB APPROVAL DATE:

DESIGN: BRANDEN FRY
SOFTWARE: CHRIS MARLOW

PROJECT MANAGER:
JASON BRYAN

REVISIONS	
DESCRIPTION	BY/ DATE
1	
2	
3	
4	
5	
6	

FILENAME: JCGA-102.2.DWG

DWG NO.

ES102.2

SEC2 EM POWER DISTRIBUTION