


E2.2		FILE NUMBER C02E22		PROJECT TITLE LIGHTING PLAN AREA 'C'		RELEASE DATE 12/21/97 DESCRIPTION MECHANICAL / ELECTRICAL BID PACKAGE RELEASE	
DATE 10-31-07		PROJ. NUMBER A06196		DESIGN JBL CHECKED GER		MECHANICAL / ELECTRICAL BID PACKAGE RELEASE	
CAD FILE NAME C02E22		PROJ. NUMBER A06196		JBL JBL GER		MECHANICAL / ELECTRICAL BID PACKAGE RELEASE	
DATE 10-31-07		PROJ. NUMBER A06196		JBL JBL GER		MECHANICAL / ELECTRICAL BID PACKAGE RELEASE	

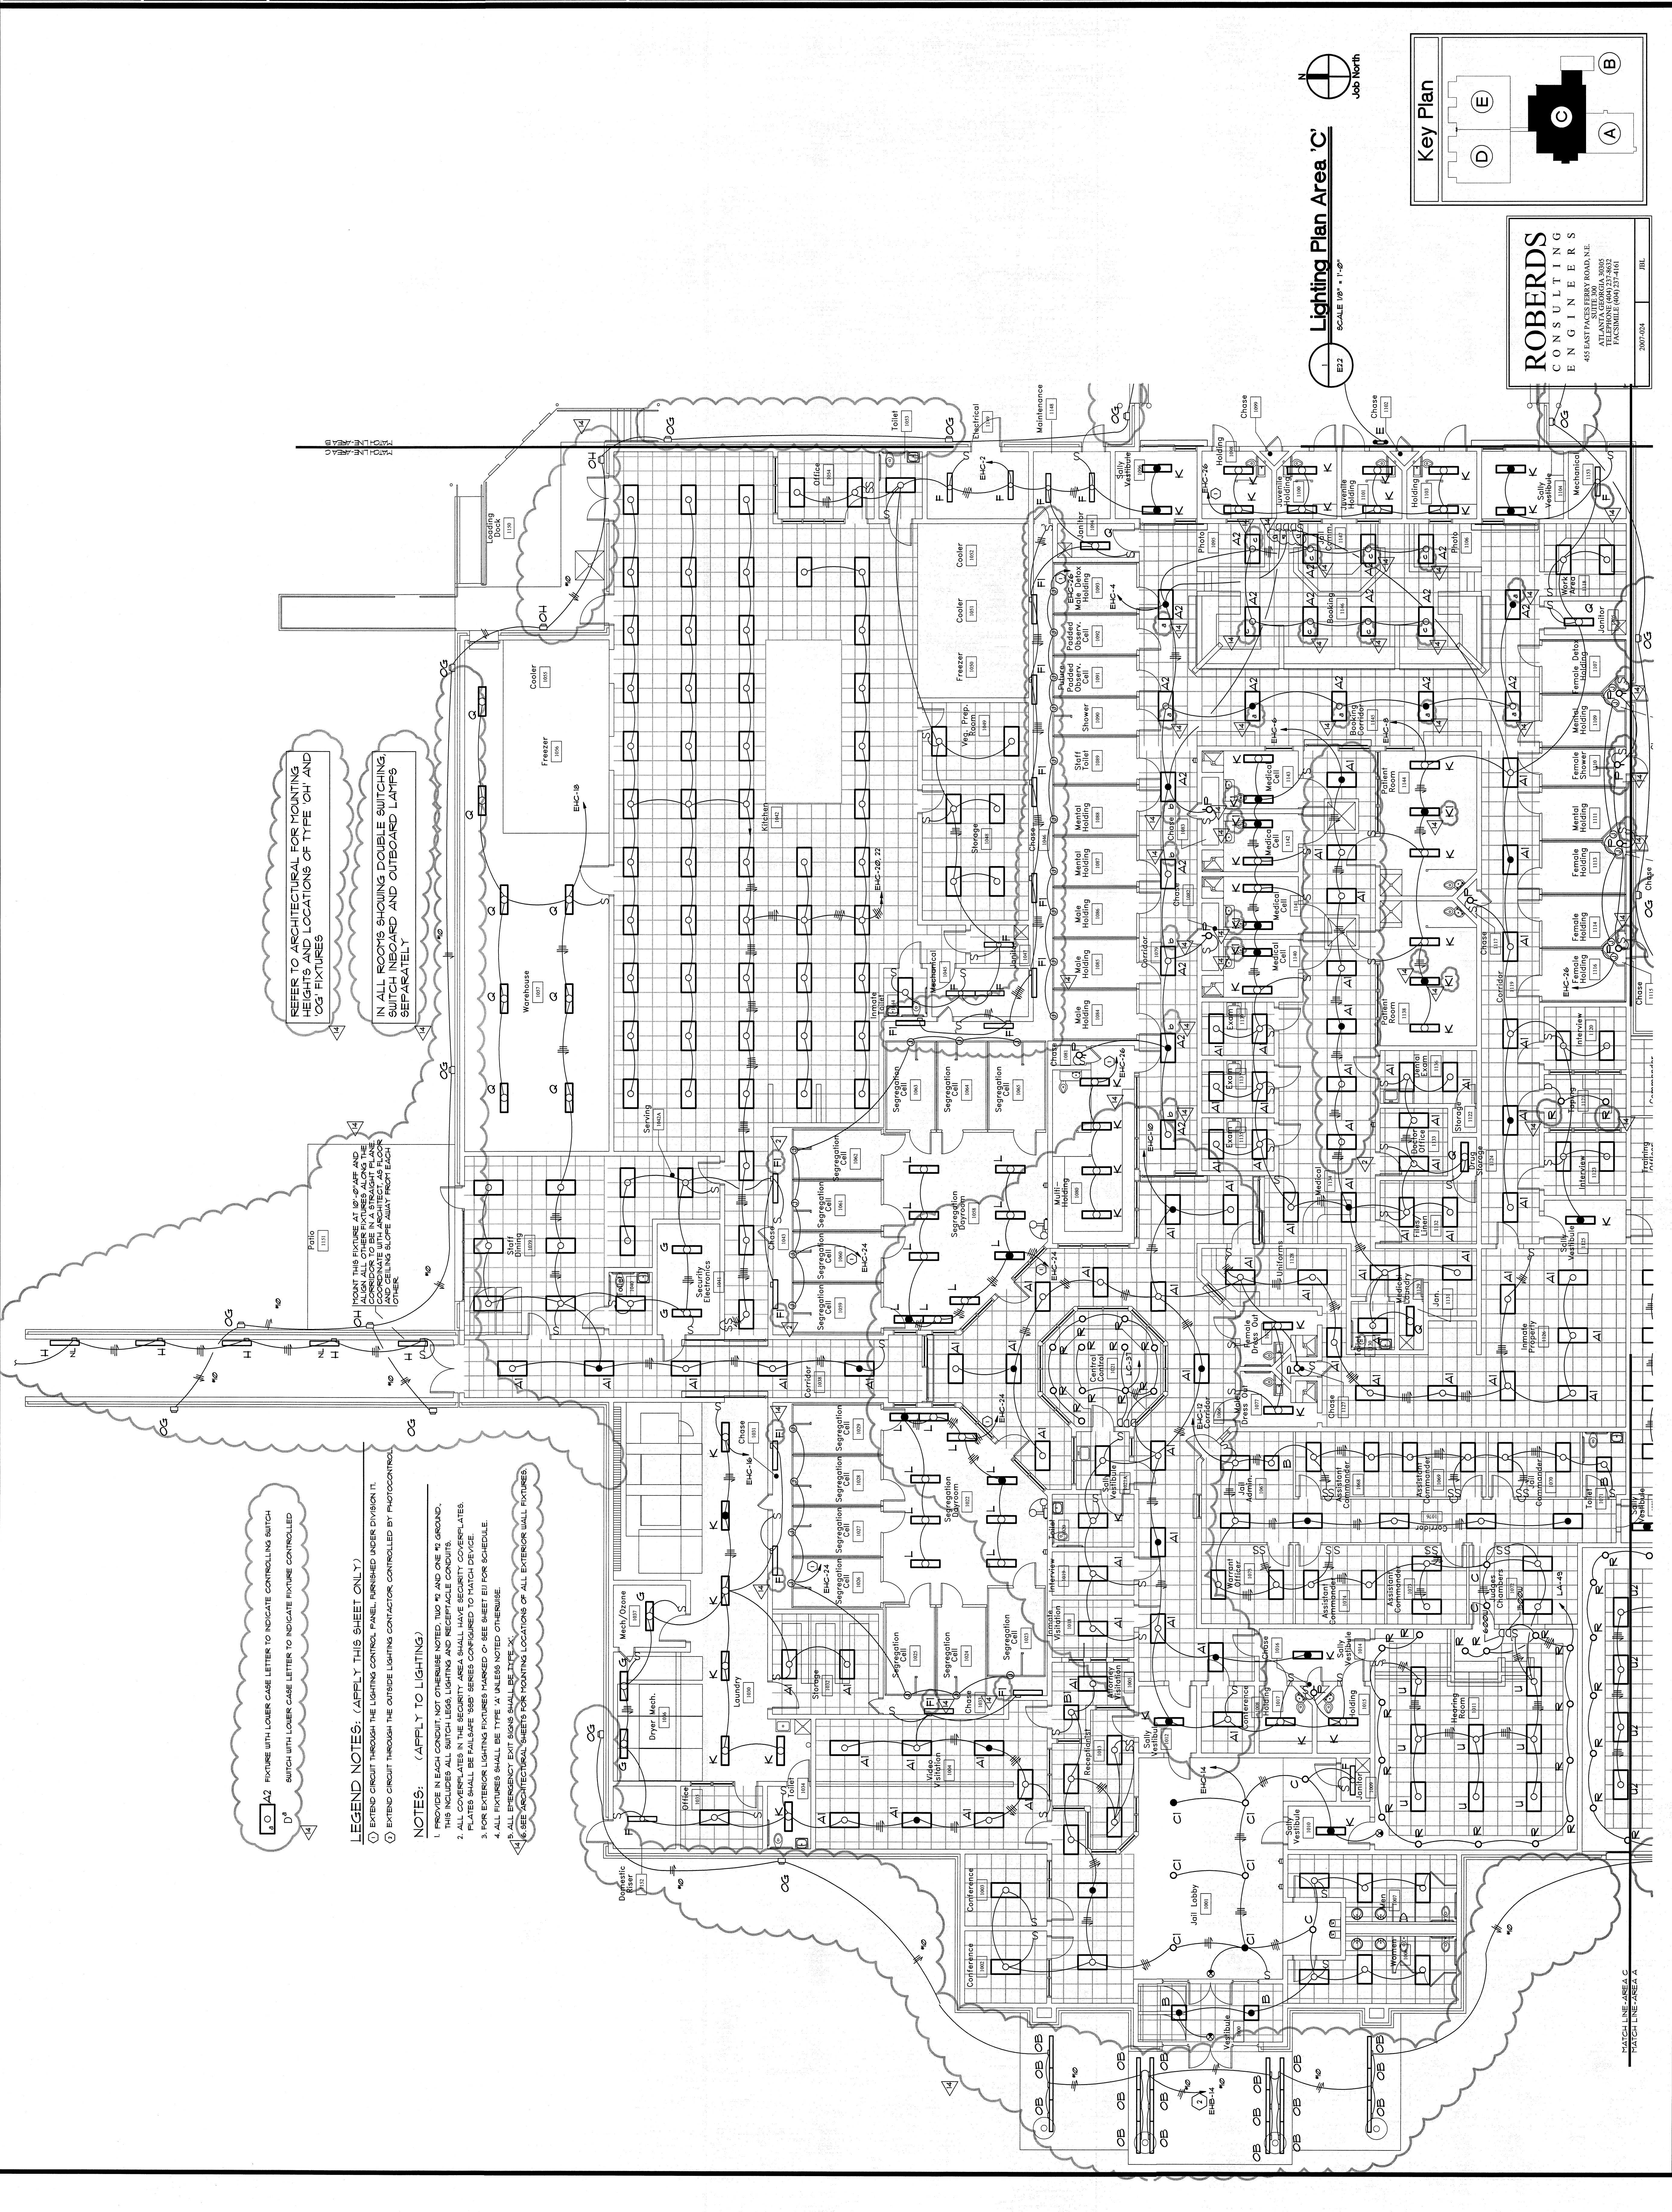

REFER TO ARCHITECTURAL FOR MOUNTING
HEIGHTS AND LOCATIONS OF TYPE OH AND
OG FIXTURES

IN ALL ROOMS SHOWING DOUBLE SWITCHING,
SWITCH INBOARD AND OUTBOARD LAMPS
SEPARATELY

OH MOUNT THIS FIXTURE AT 10'-0" AFF AND
ALIGN ALL OTHER FIXTURES ALONG THE
COORDINATE WITH ARCHITECT AS FLOOR
AND CEILING FLORE AWAY FROM EACH
OTHER

A2 FIXTURE WITH LOWER CASE LETTER TO INDICATE CONTROLLING SWITCH
D* SWITCH WITH LOWER CASE LETTER TO INDICATE FIXTURE CONTROLLED

LEGEND NOTES: (APPLY THIS SHEET ONLY)

1. PROVIDE EACH CONDUIT NOT OTHERWISE NOTED TWO #12 AND ONE #14 GROUND.

2. ALL COVERPLATES IN THE SECURITY AREA SHALL HAVE SECURITY COVERPLATES.

3. FOR EXTERIOR LIGHTING FIXTURES MARKED 'O' SEE SHEET E1 FOR SCHEDULE.

4. ALL EXTERIOR LIGHTING FIXTURES MARKED 'O' SEE SHEET E1 FOR SCHEDULE.

5. ALL EXTERIOR LIGHTING FIXTURES MARKED 'O' SEE SHEET E1 FOR SCHEDULE.

6. SEE ARCHITECTURAL SHEETS FOR MOUNTING LOCATIONS OF ALL EXTERIOR WALL FIXTURES.

NOTES: (APPLY TO LIGHTING)

1. PROVIDE EACH CONDUIT NOT OTHERWISE NOTED TWO #12 AND ONE #14 GROUND.


2. ALL COVERPLATES IN THE SECURITY AREA SHALL HAVE SECURITY COVERPLATES.

3. FOR EXTERIOR LIGHTING FIXTURES MARKED 'O' SEE SHEET E1 FOR SCHEDULE.

4. ALL EXTERIOR LIGHTING FIXTURES MARKED 'O' SEE SHEET E1 FOR SCHEDULE.

5. ALL EXTERIOR LIGHTING FIXTURES MARKED 'O' SEE SHEET E1 FOR SCHEDULE.

6. SEE ARCHITECTURAL SHEETS FOR MOUNTING LOCATIONS OF ALL EXTERIOR WALL FIXTURES.

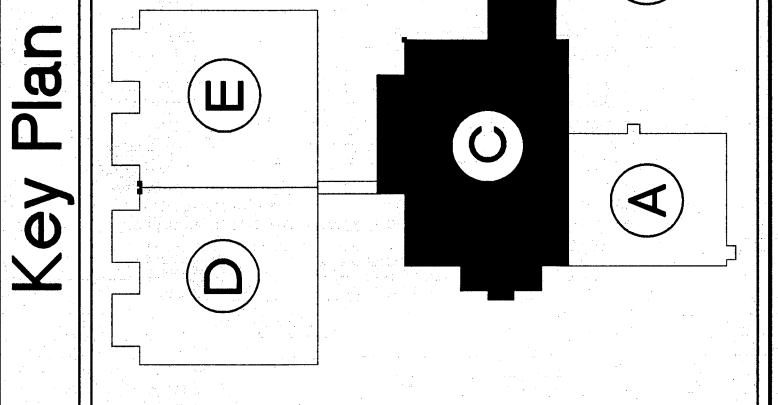

ROBERDS
CONSULTING
ENGINEERS
455 EAST PACIFIC FERRY ROAD, N.E.
ATLANTA, GEORGIA 30305
PHONE (404) 527-4161
FAX (404) 527-4161

Lighting Plan Area 'C'
SCALE 1/8" = 1'-0"

